

- NOTES:**
1. THIS FOUNDATION DRAWING AND NOTES ARE FOR REVIEW ONLY. ACTUAL FOUNDATION DESIGN MAY HAVE TO BE APPROVED BY A PROFESSIONAL ENGINEER OR A REGISTERED ARCHITECT.
  2. ALL CONSTRUCTION AND MATERIALS BELOW THE BOTTOM OF THE FLOOR JOISTS IS THE RESPONSIBILITY OF THE BUILDER. FOUNDATION WALL, FOOTER, LOLLY COLUMNS & PADS ARE ALL TO BE DETERMINED ON-SITE IN ACCORDANCE WITH LOCAL CODES & CONDITIONS.
  3. REINFORCED MASONRY UNIT REQUIRED AT CENTER BEARING LOCATIONS.
  4. LOLLY COLUMNS ARE TO BE SPACED ACCORDING TO SPAN SCHEDULE BASED ON TYPE OF HOUSE, LOCAL SNOW LOAD & WIDTH OF UNIT. ADD'L COLUMNS MAY BE REQ'D & ARE NOTED ON FLOOR PLAN. LOLLY COLUMN SPACING IS BASED ON 1/2"x6"x12" STEEL PLATE BETWEEN COLUMN & CENTER BEAM.
  5. FOUNDATION IS TO BE CONSTRUCTED IN ACCORDANCE w/ALL APPLICABLE CODES.
  6. FOUNDATION SIZES REFLECT WOOD DIMENSIONS OF MODULAR UNITS, ALLOWING SHEATHING AND SIDING TO OVERHANG THE FOUNDATION. IF STYROFOAM IS USED FOUNDATION MAY BE INCREASED IN LENGTH AND WIDTH TO ACCOMMODATE.
  7. PERIMETER FLOOR JOISTS TO BE ATTACHED TO SILL PLATE w/16d NAILS AT 16" O.C.
  8. INSTALLATION OF WASHER, DRYER AND/OR WATER HEATER IN BASEMENT PER STATE AND LOCAL CODES IS THE RESPONSIBILITY OF MODULAR MANUFACTURERS, BUILDER.
  9. SMOKE DETECTORS IN BASEMENT SHALL BE THE RESPONSIBILITY OF THE BUILDER TO PROVIDE AND INSTALL. (COIL WIRE IN BSMT BY MODULAR MANUFACTURER, INC)
  10. CRAWL SPACE FOUNDATION REQUIRES A MINIMUM 18"x24" ACCESS OPENING, INSECT & RODENT PROOF CROSS VENTS WITHIN 3' OF CORNERS AND PROVIDE 1/150 OF FLOOR AREA WITH VENTILATION.
  11. SEE MODULAR MANUFACTURERS' SUBMISSION SET PAGE FOR ADDITIONAL NOTES AND DETAILS.

**NOTE: COLUMN LOCATIONS TO BE VERIFIED BY FACTORY PRIOR TO INSTALLATION**

REVISION:	DATE:	BY:	REVISION:	DATE:	BY:
0	08/22/2023	SC	5	09/26/2023	SC
1	08/23/2023	SC	6	09/29/2023	SC
2	09/01/2023	SC	7	10/25/2023	SC
3	09/09/2023	SC			
4	09/20/2023	SC			

**FOUNDATION PLAN**

CUSTOMER:  
ADDRESS:


**impresa MODULAR**  
 1586 WINCHESTER AVE.  
 MARTINSBURG, WV 25405  
 FAX: 877-419-2505  
 WWW.IMPRESAMODULAR.COM

SCALE:  
3/16"=1'-0"

SHEET:

**1.0**

**DISCLAIMER:** THESE DRAWINGS ARE ARTISTS RENDERINGS ONLY AND FINAL PROJECT MAY NOT BE IDENTICAL TO THAT SHOWN HERE. PROPRIETARY WORK PRODUCT AND PROPERTY OF EXPRESS HOMES, INC. DBA IMPRESA MODULAR AND DEVELOPED FOR THE EXCLUSIVE USE OF IMPRESA MODULAR. USE OF THESE DRAWINGS AND CONCEPTS CONTAINED THEREIN WITHOUT WRITTEN PERMISSION OF IMPRESA MODULAR IS PROHIBITED.

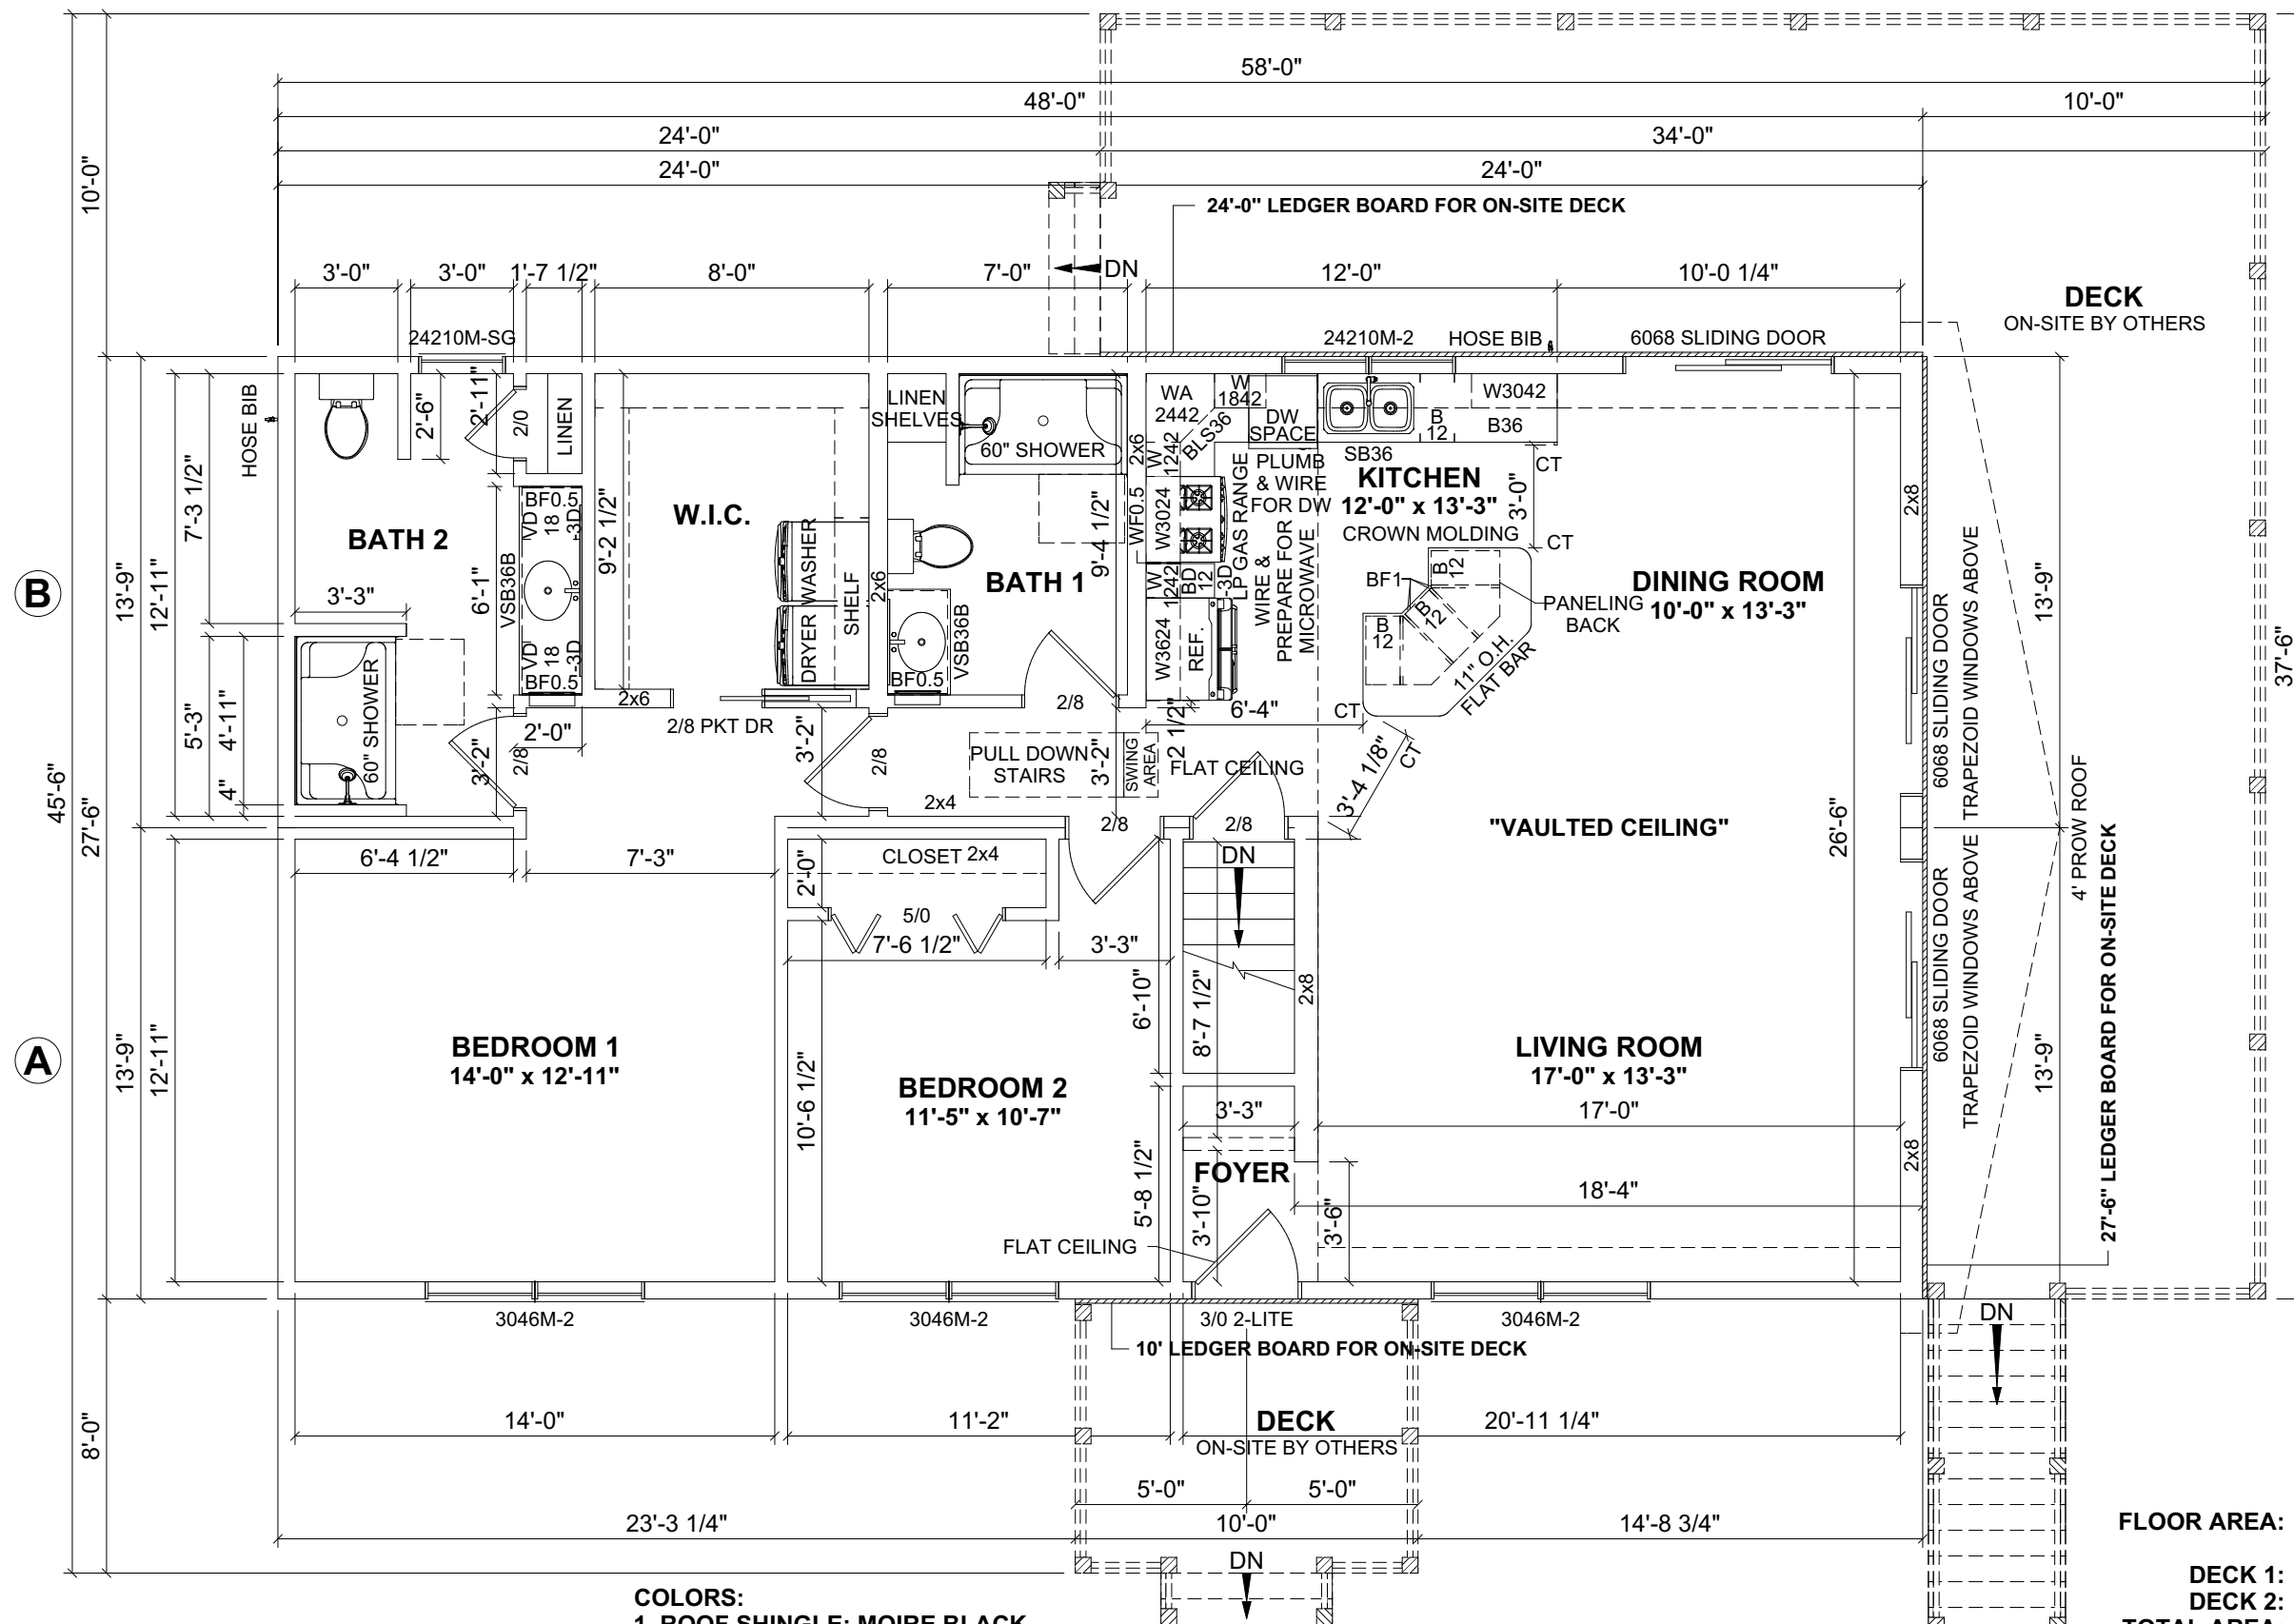

- NOTES:**
- 2x6 EXTERIOR WALLS EXCEPT AS NOTED.
  - 2x4 INTERIOR WALLS EXCEPT AS NOTED.
  - 9'-0" CEILING HEIGHT.
  - 8/12 STORAGE ROOF EXCEPT AS NOTED.
  - MERRILLAT CLASSIC CABINETS.
  - PLY GEM PRO SERIES DOUBLE HUNG WINDOWS.

- COLORS:**
- ROOF SHINGLE: MOIRE BLACK
  - SIDING: CASTLE STONE
  - EXTERIOR DOORS: BLACK EMERALD FRONT DOOR EXTERIOR / WHITE INTERIOR
  - INTERIOR WALL: WHITE
  - KITCHEN CABINETS: KONA
  - KITCHEN COUNTERTOPS: PLATINUM
  - KITCHEN APPLIANCES: BLACK

**FLOOR AREA: 1,320 SQ.FT.**  
**DECK 1: 80 SQ.FT.**  
**DECK 2: 615 SQ.FT.**  
**TOTAL AREA: 695 SQ.FT.**

REVISION:	DATE:	BY:	REVISION:	DATE:	BY:
0	08/22/2023	SC	5	09/26/2023	SC
1	08/23/2023	SC	6	09/29/2023	SC
2	09/01/2023	SC	7	10/25/2023	SC
3	09/09/2023	SC			
4	09/20/2023	SC			


**FLOOR PLAN**

**CUSTOMER:**  
**ADDRESS:**

**impresa MODULAR**  
 1566 WINCHESTER AVE.  
 MARTINSBURG, WV 25405  
 FAX: 877-419-2505  
 WWW.IMPRESAMODULAR.COM

**SCALE:**  
 3/16"=1'-0"  
**SHEET:**

ELECTRICAL LEGEND	
	ELECTRIC PANEL
	METER
	LIGHT SWITCH
	3 WAY LIGHT SWITCH
	4 WAY LIGHT SWITCH
	SINGLE DIMMER LIGHT SWITCH
	3 WAY DIMMER LIGHT SWITCH
	110V DUPLEX RECEPTACLE
	110V DUPLEX SPLIT RECEPTACLE
	EXTERIOR WP GFI OUTLET
	220V DUPLEX RECEPTACLE
	CEILING MOUNTED OUTLET
	FLOOR OUTLET
	QUADRUPLEX RECEPTACLE
	STANDARD CEILING LIGHT
	PENDANT LIGHT
	RECESSED LIGHT
	UNDER CABINET LIGHT
	CHANDELIER LIGHT
	VANITY WALL MOUNT LIGHT
	WALL SCONCE
	EXTERIOR WALL LIGHT
	SPOT LIGHT
	MOTION LIGHT
	FLUORESCENT
	JUNCTION BOX
	EXHAUST FAN
	EXHAUST FAN / LIGHT
	EXHAUST FAN, LIGHT & HEAT
	CEILING FAN OR FAN/LIGHT -SEE PLAN FOR INFO
	SMOKE DETECTOR
	CO/SMOKE DETECTOR
	TV
	PHONE
	HUMIDISTAT
	THERMOSTAT
	ETHERNET
	CABLE
	DOOR CHIME
	DOORBELL
	EMERGENCY LIGHTING
	EXIT SIGN

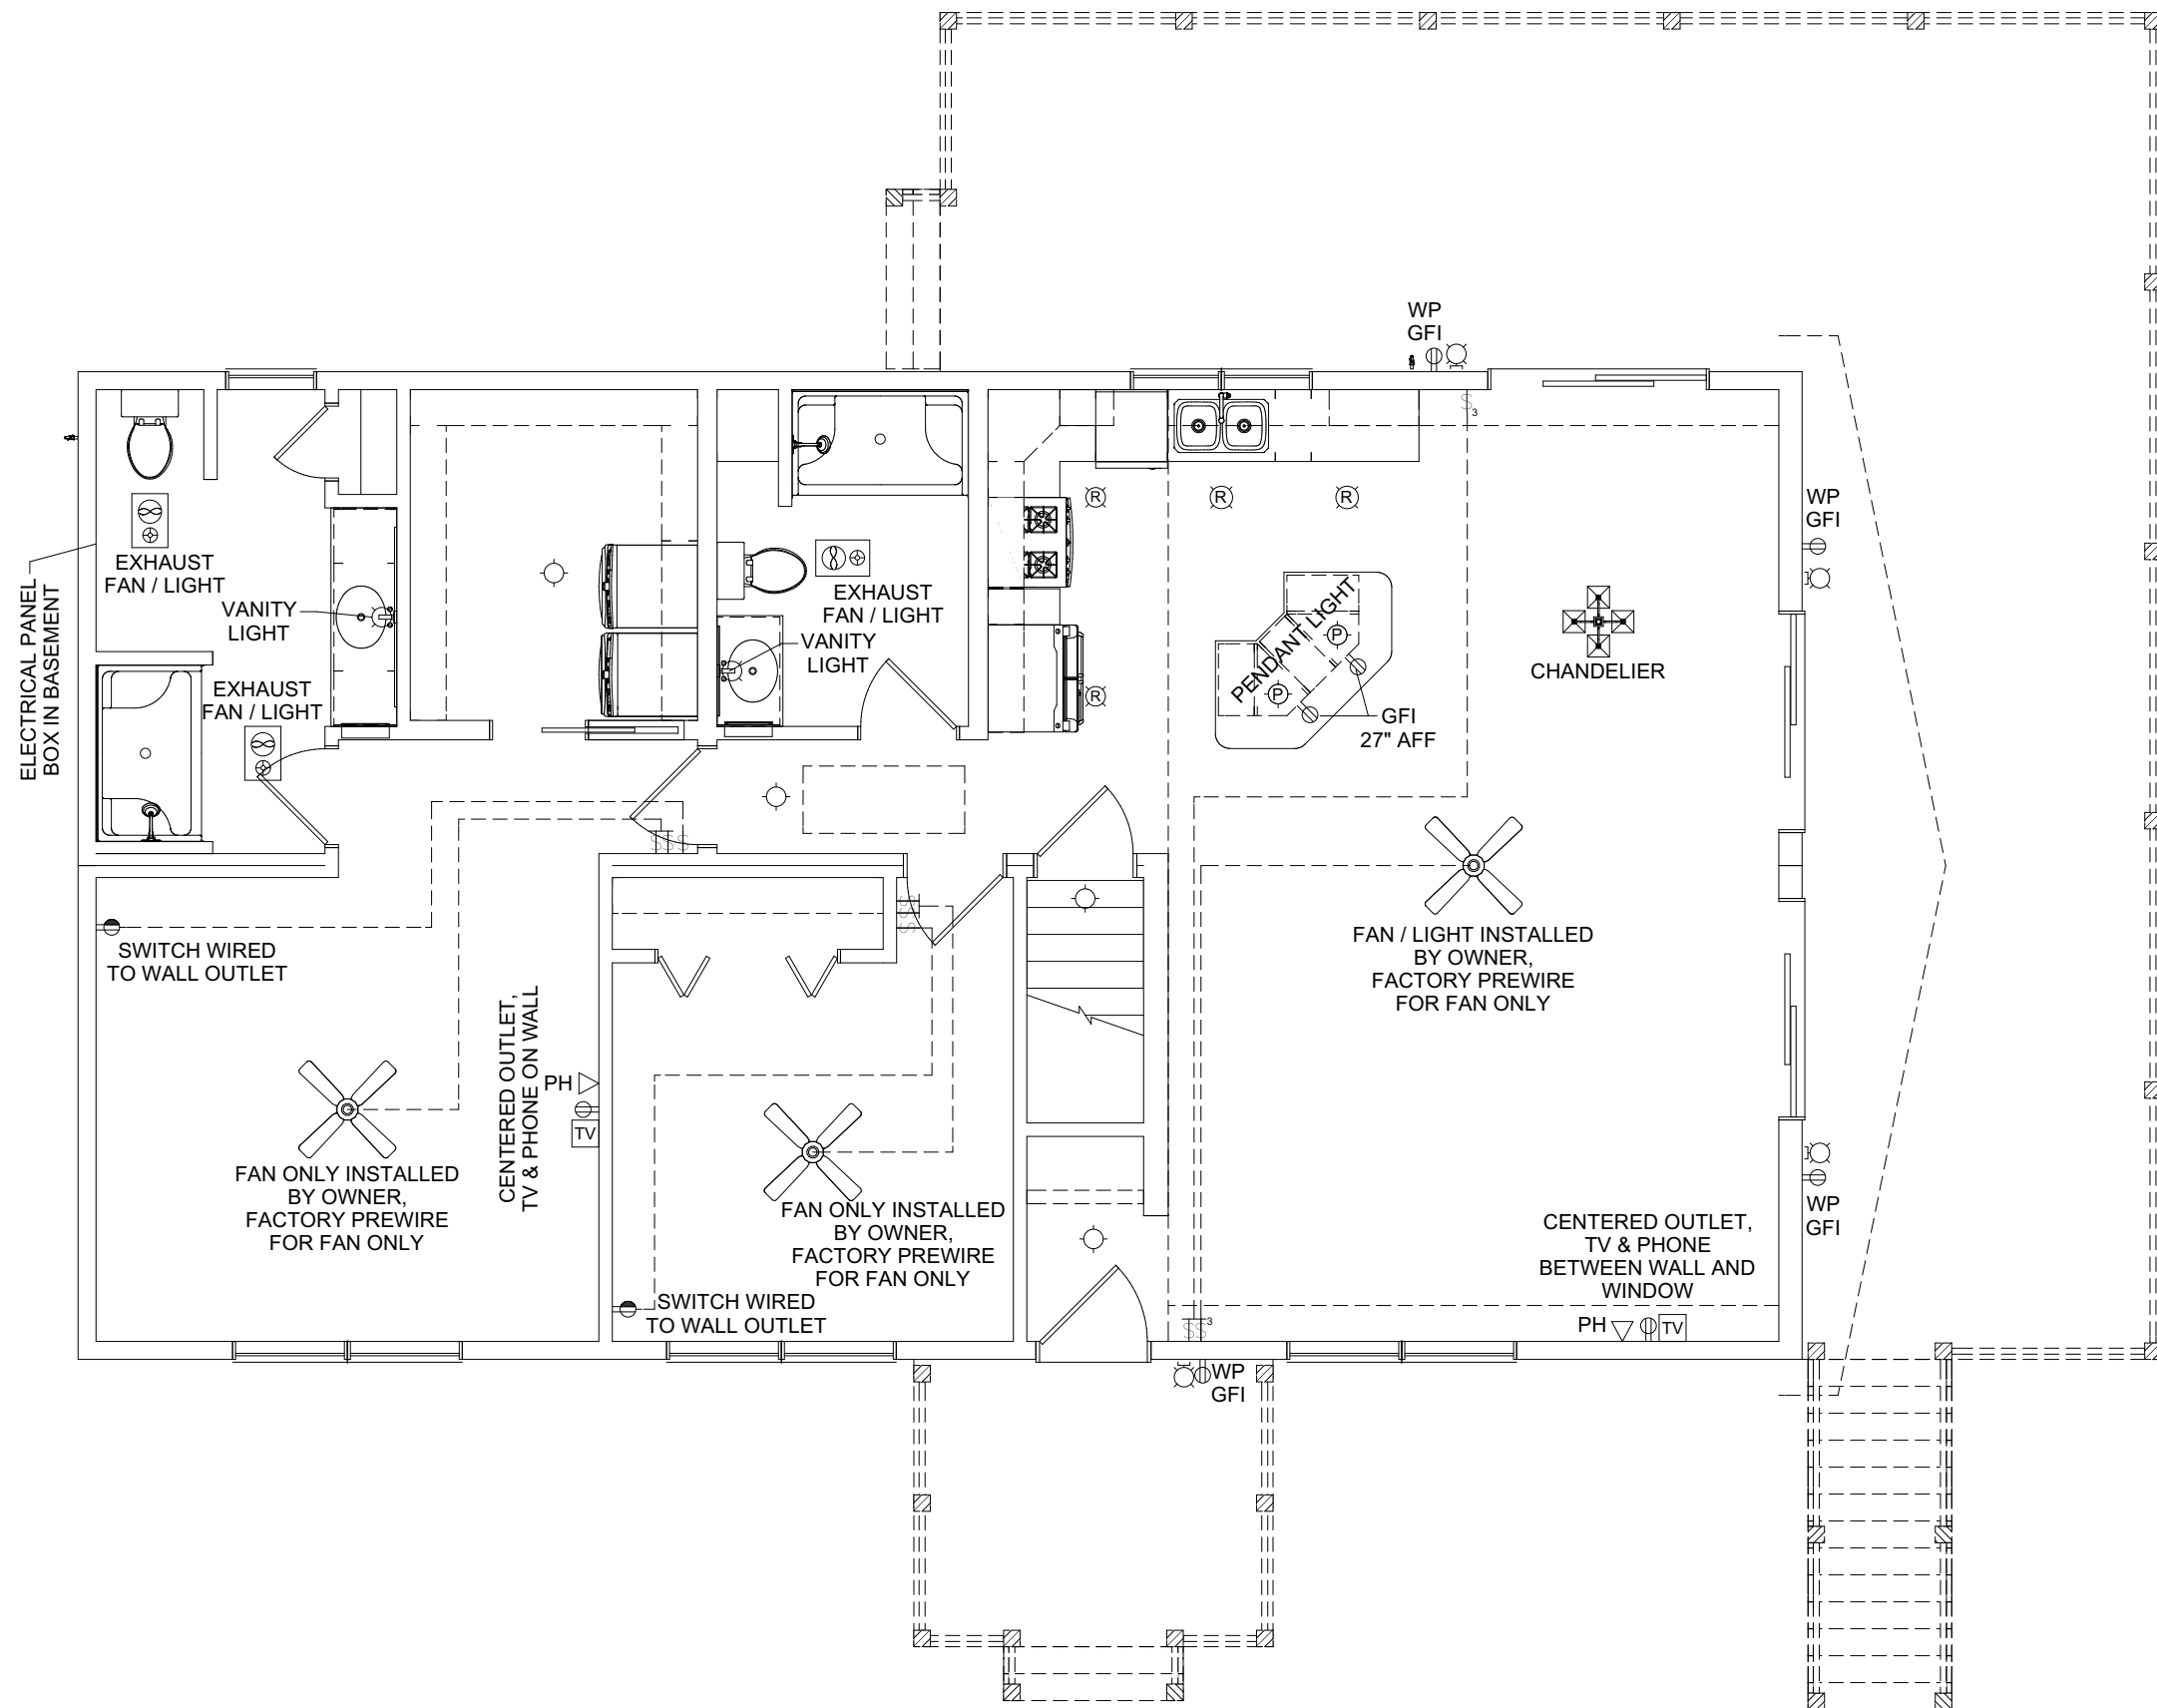

REVISION:	DATE:	BY:	REVISION:	DATE:	BY:
0	08/22/2023	SC	5	09/26/2023	SC
1	08/23/2023	SC	6	09/29/2023	SC
2	09/01/2023	SC	7	10/25/2023	SC
3	09/09/2023	SC			
4	09/20/2023	SC			

**FLOOR ELECTRICAL PLAN**

CUSTOMER: \_\_\_\_\_

ADDRESS: \_\_\_\_\_


**impresa MODULAR**  
 1586 WINCHESTER AVE.  
 MARTINSBURG, WV 25405  
 FAX: 877-419-2505  
 WWW.IMPRESAMODULAR.COM

SCALE: 3/16"=1'-0"

SHEET:

1.1

**DISCLAIMER:** THESE DRAWINGS ARE ARTISTS RENDERINGS ONLY AND FINAL PROJECT MAY NOT BE IDENTICAL TO THAT SHOWN HERE. PROPRIETARY WORK PRODUCT AND PROPERTY OF EXPRESS HOMES, INC. DBA IMPRESA MODULAR AND DEVELOPED FOR THE EXCLUSIVE USE OF IMPRESA MODULAR. USE OF THESE DRAWINGS AND CONCEPTS CONTAINED THEREIN WITHOUT WRITTEN PERMISSION OF IMPRESA MODULAR IS PROHIBITED.

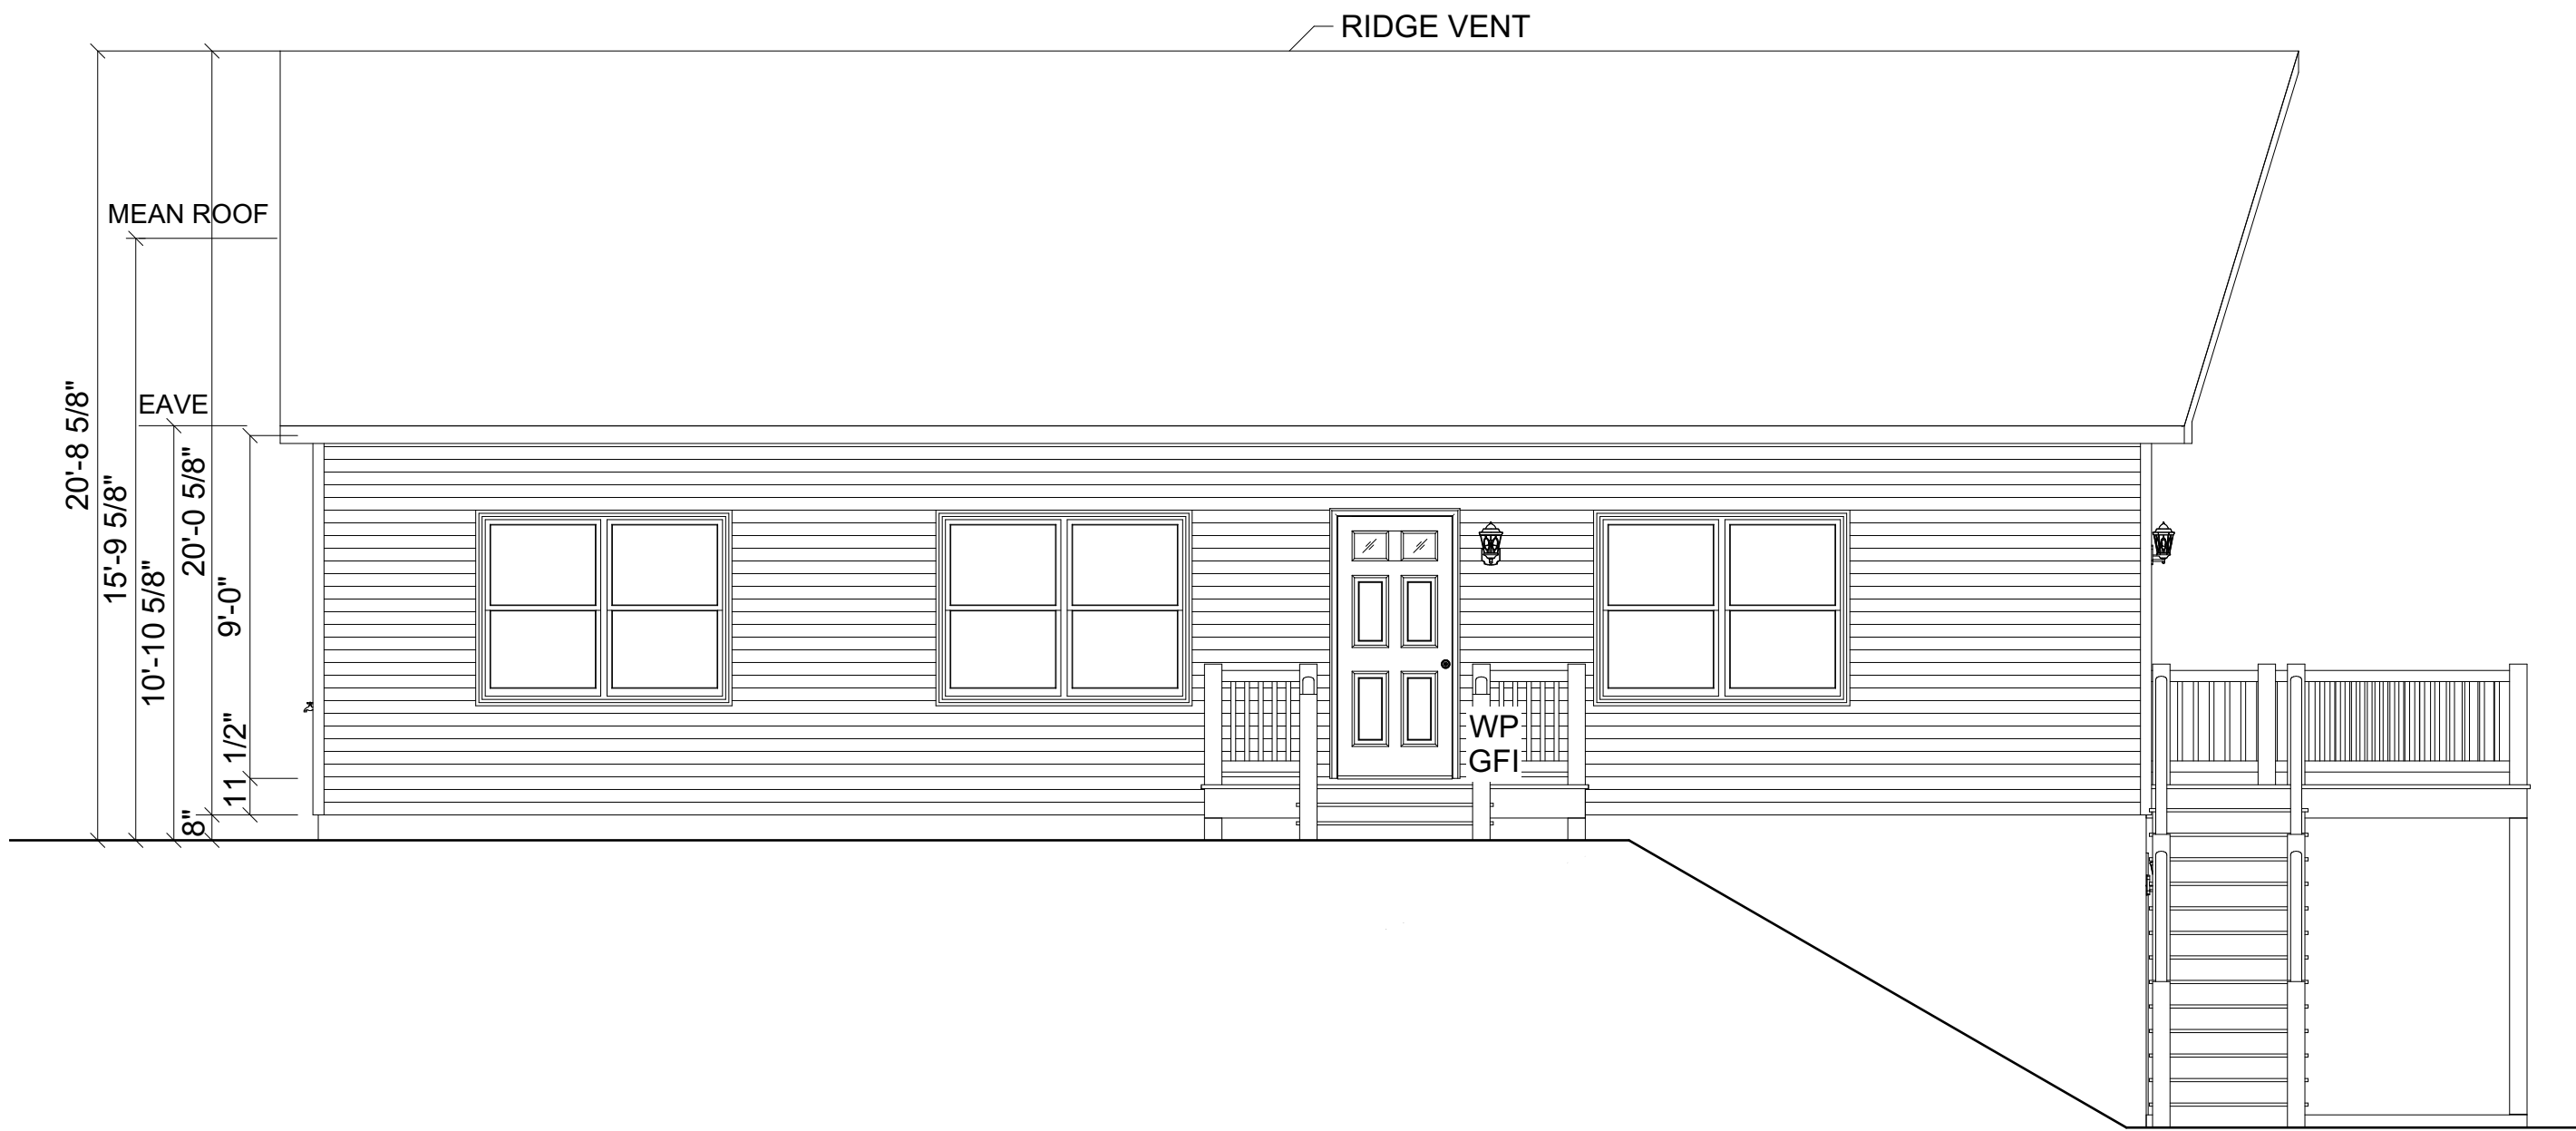

**FRONT ELEVATION**

REVISION:	DATE:	BY:	REVISION:	DATE:	BY:
0	08/22/2023	SC	5	09/26/2023	SC
1	08/23/2023	SC	6	09/29/2023	SC
2	09/01/2023	SC	7	10/25/2023	SC
3	09/09/2023	SC			
4	09/20/2023	SC			

**ELEVATION**


CUSTOMER:  
ADDRESS:

**impresa**  
MODULAR  
1586 WINCHESTER AVE.  
MARTINSBURG, WV 25405  
FAX: 877-419-2505  
WWW.IMPRESAMODULAR.COM

SCALE:  
N.T.S.  
SHEET:

**2.0**

**DISCLAIMER:** THESE DRAWINGS ARE ARTISTS RENDERINGS ONLY AND FINAL PROJECT MAY NOT BE IDENTICAL TO THAT SHOWN HERE. PROPRIETARY WORK PRODUCT AND PROPERTY OF EXPRESS HOMES, INC. DBA IMPRESA MODULAR AND DEVELOPED FOR THE EXCLUSIVE USE OF IMPRESA MODULAR. USE OF THESE DRAWINGS AND CONCEPTS CONTAINED THEREIN WITHOUT WRITTEN PERMISSION OF IMPRESA MODULAR IS PROHIBITED.

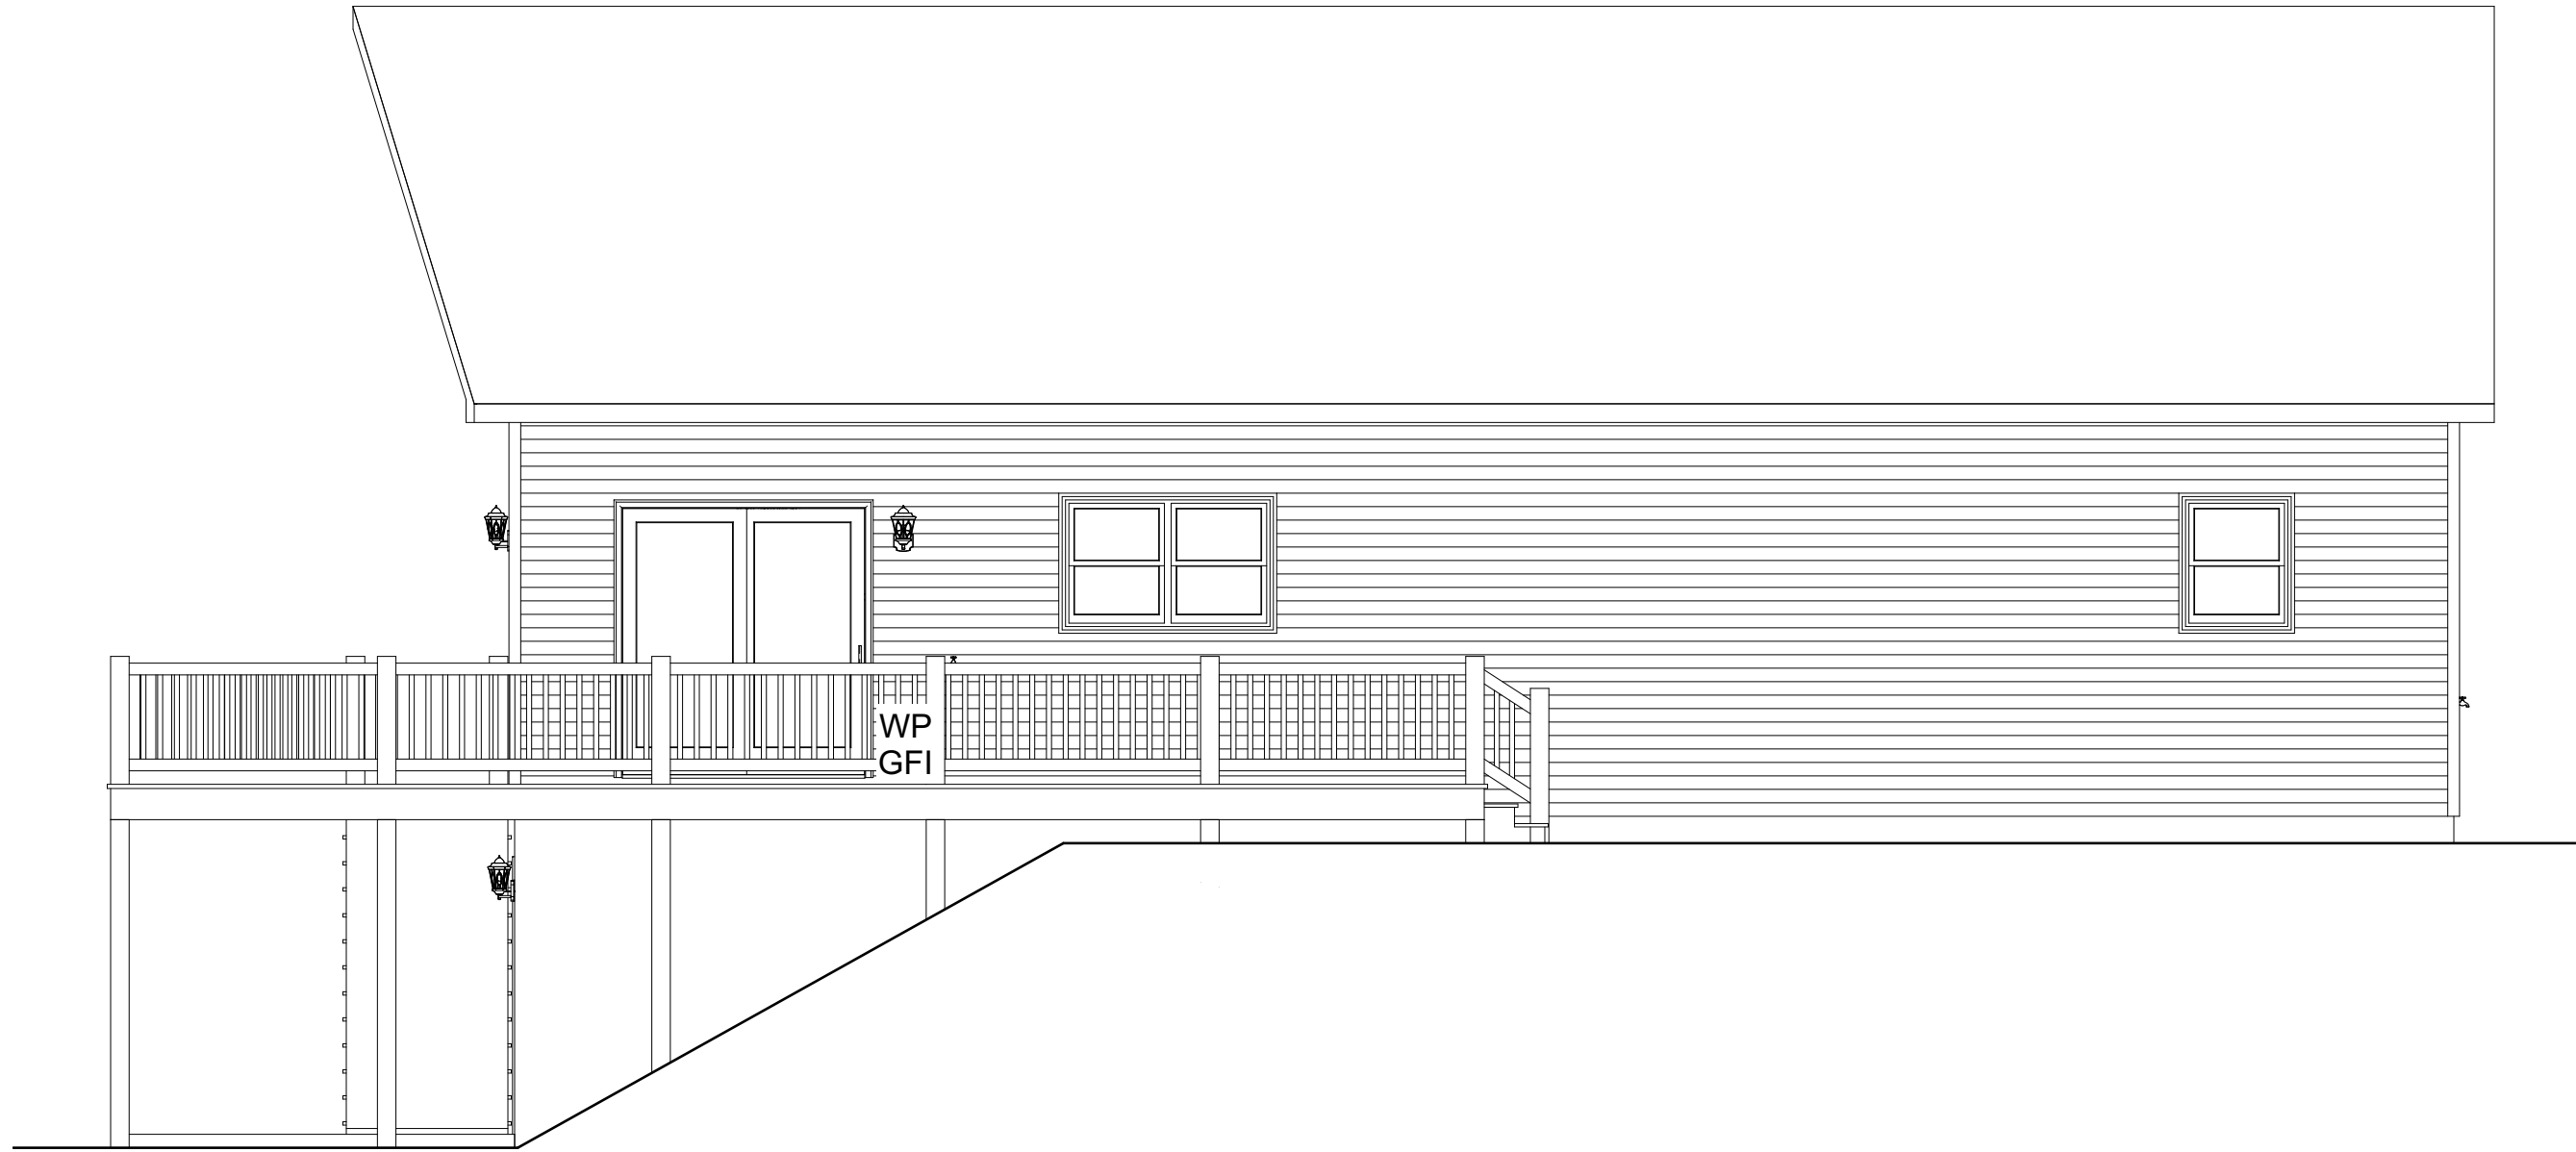

WP  
GFI

**REAR ELEVATION**

REVISION:	DATE:	BY:	REVISION:	DATE:	BY:
0	08/22/2023	SC	5	09/26/2023	SC
1	08/23/2023	SC	6	09/29/2023	SC
2	09/01/2023	SC	7	10/25/2023	SC
3	09/09/2023	SC			
4	09/20/2023	SC			

**ELEVATION**


CUSTOMER:  
ADDRESS:

**impresa**  
MODULAR  
1586 WINCHESTER AVE.  
MARTINSBURG, WV 25405  
FAX: 877-419-2505  
WWW.IMPRESAMODULAR.COM

SCALE:  
N.T.S.  
SHEET:

**2.1**

**DISCLAIMER:** THESE DRAWINGS ARE ARTISTS RENDERINGS ONLY AND FINAL PROJECT MAY NOT BE IDENTICAL TO THAT SHOWN HERE. PROPRIETARY WORK PRODUCT AND PROPERTY OF EXPRESS HOMES, INC. DBA IMPRESA MODULAR AND DEVELOPED FOR THE EXCLUSIVE USE OF IMPRESA MODULAR. USE OF THESE DRAWINGS AND CONCEPTS CONTAINED THEREIN WITHOUT WRITTEN PERMISSION OF IMPRESA MODULAR IS PROHIBITED.

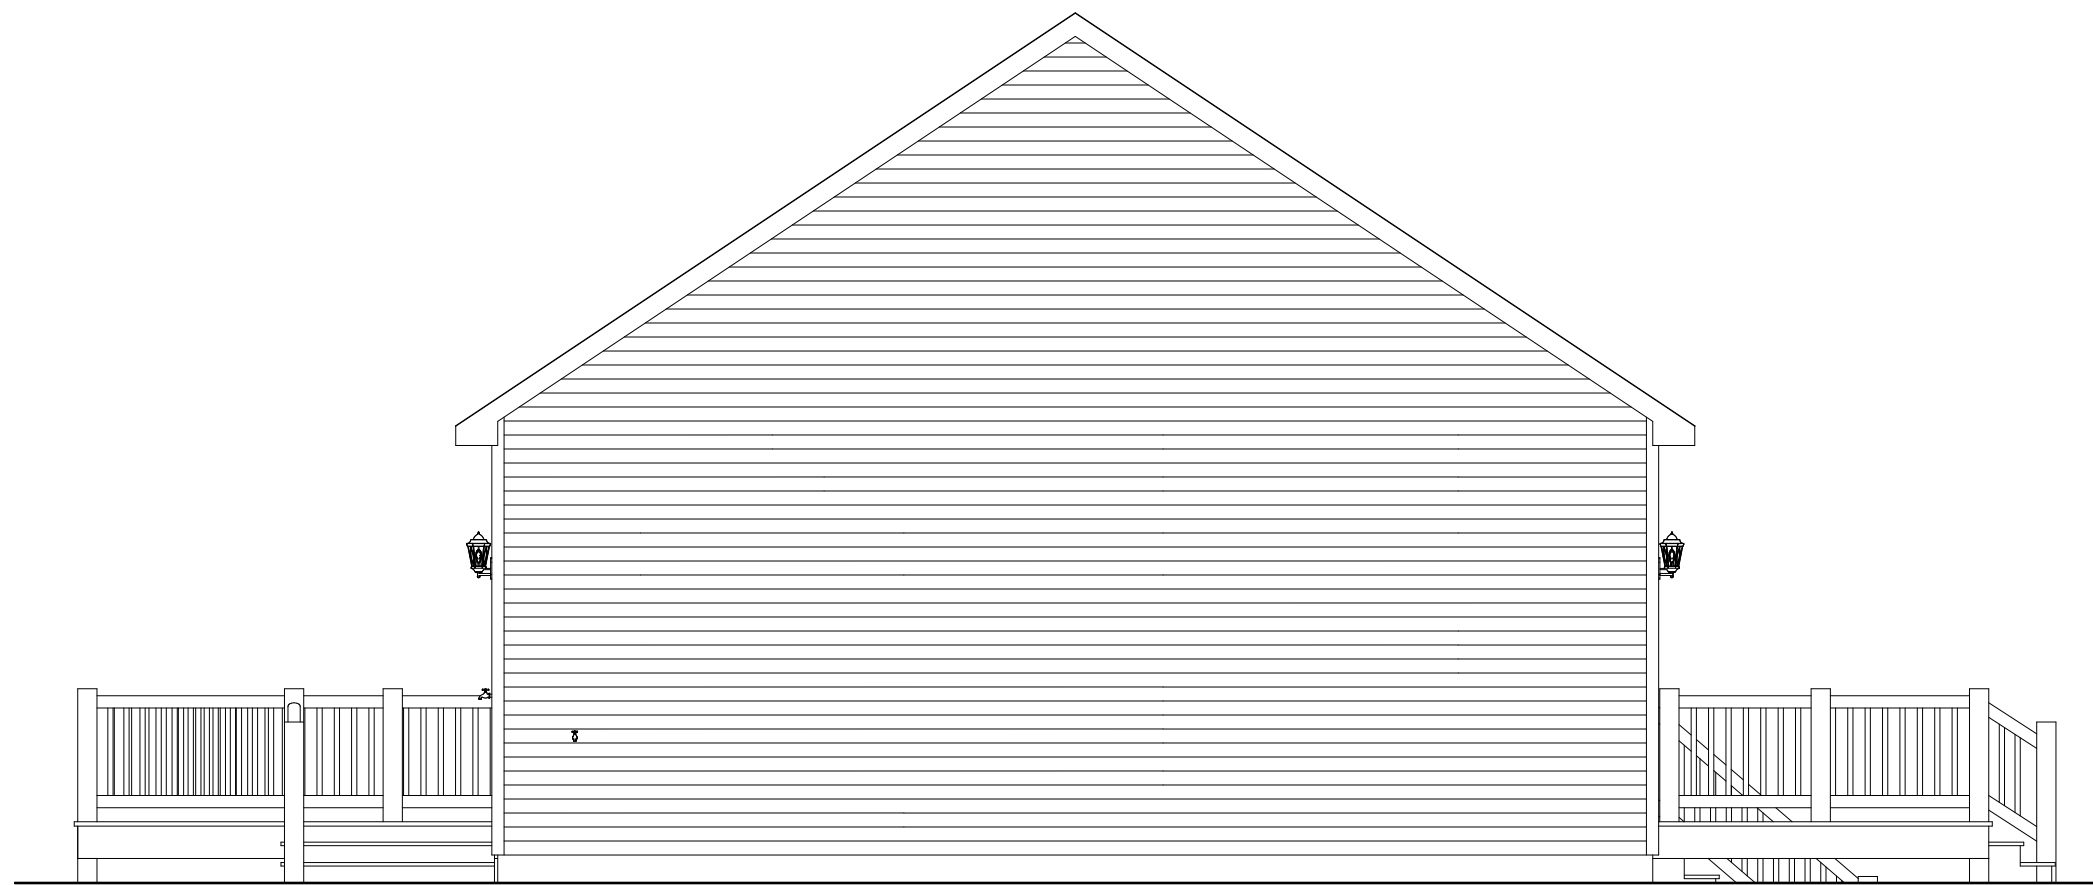

**LEFT ELEVATION**

REVISION:	DATE:	BY:	REVISION:	DATE:	BY:
0	08/22/2023	SC	5	09/26/2023	SC
1	08/23/2023	SC	6	09/29/2023	SC
2	09/01/2023	SC	7	10/25/2023	SC
3	09/09/2023	SC			
4	09/20/2023	SC			


<b>ELEVATION</b>	
CUSTOMER:	
ADDRESS:	

**impresa**  
MODULAR

1586 WINCHESTER AVE.  
MARTINSBURG, WV 25405  
FAX: 877-419-2505  
WWW.IMPRESAMODULAR.COM

SCALE:	N.T.S.
SHEET:	<b>2.2</b>

**DISCLAIMER:** THESE DRAWINGS ARE ARTISTS RENDERINGS ONLY AND FINAL PROJECT MAY NOT BE IDENTICAL TO THAT SHOWN HERE. PROPRIETARY WORK PRODUCT AND PROPERTY OF EXPRESS HOMES, INC. DBA IMPRESA MODULAR AND DEVELOPED FOR THE EXCLUSIVE USE OF IMPRESA MODULAR. USE OF THESE DRAWINGS AND CONCEPTS CONTAINED THEREIN WITHOUT WRITTEN PERMISSION OF IMPRESA MODULAR IS PROHIBITED.

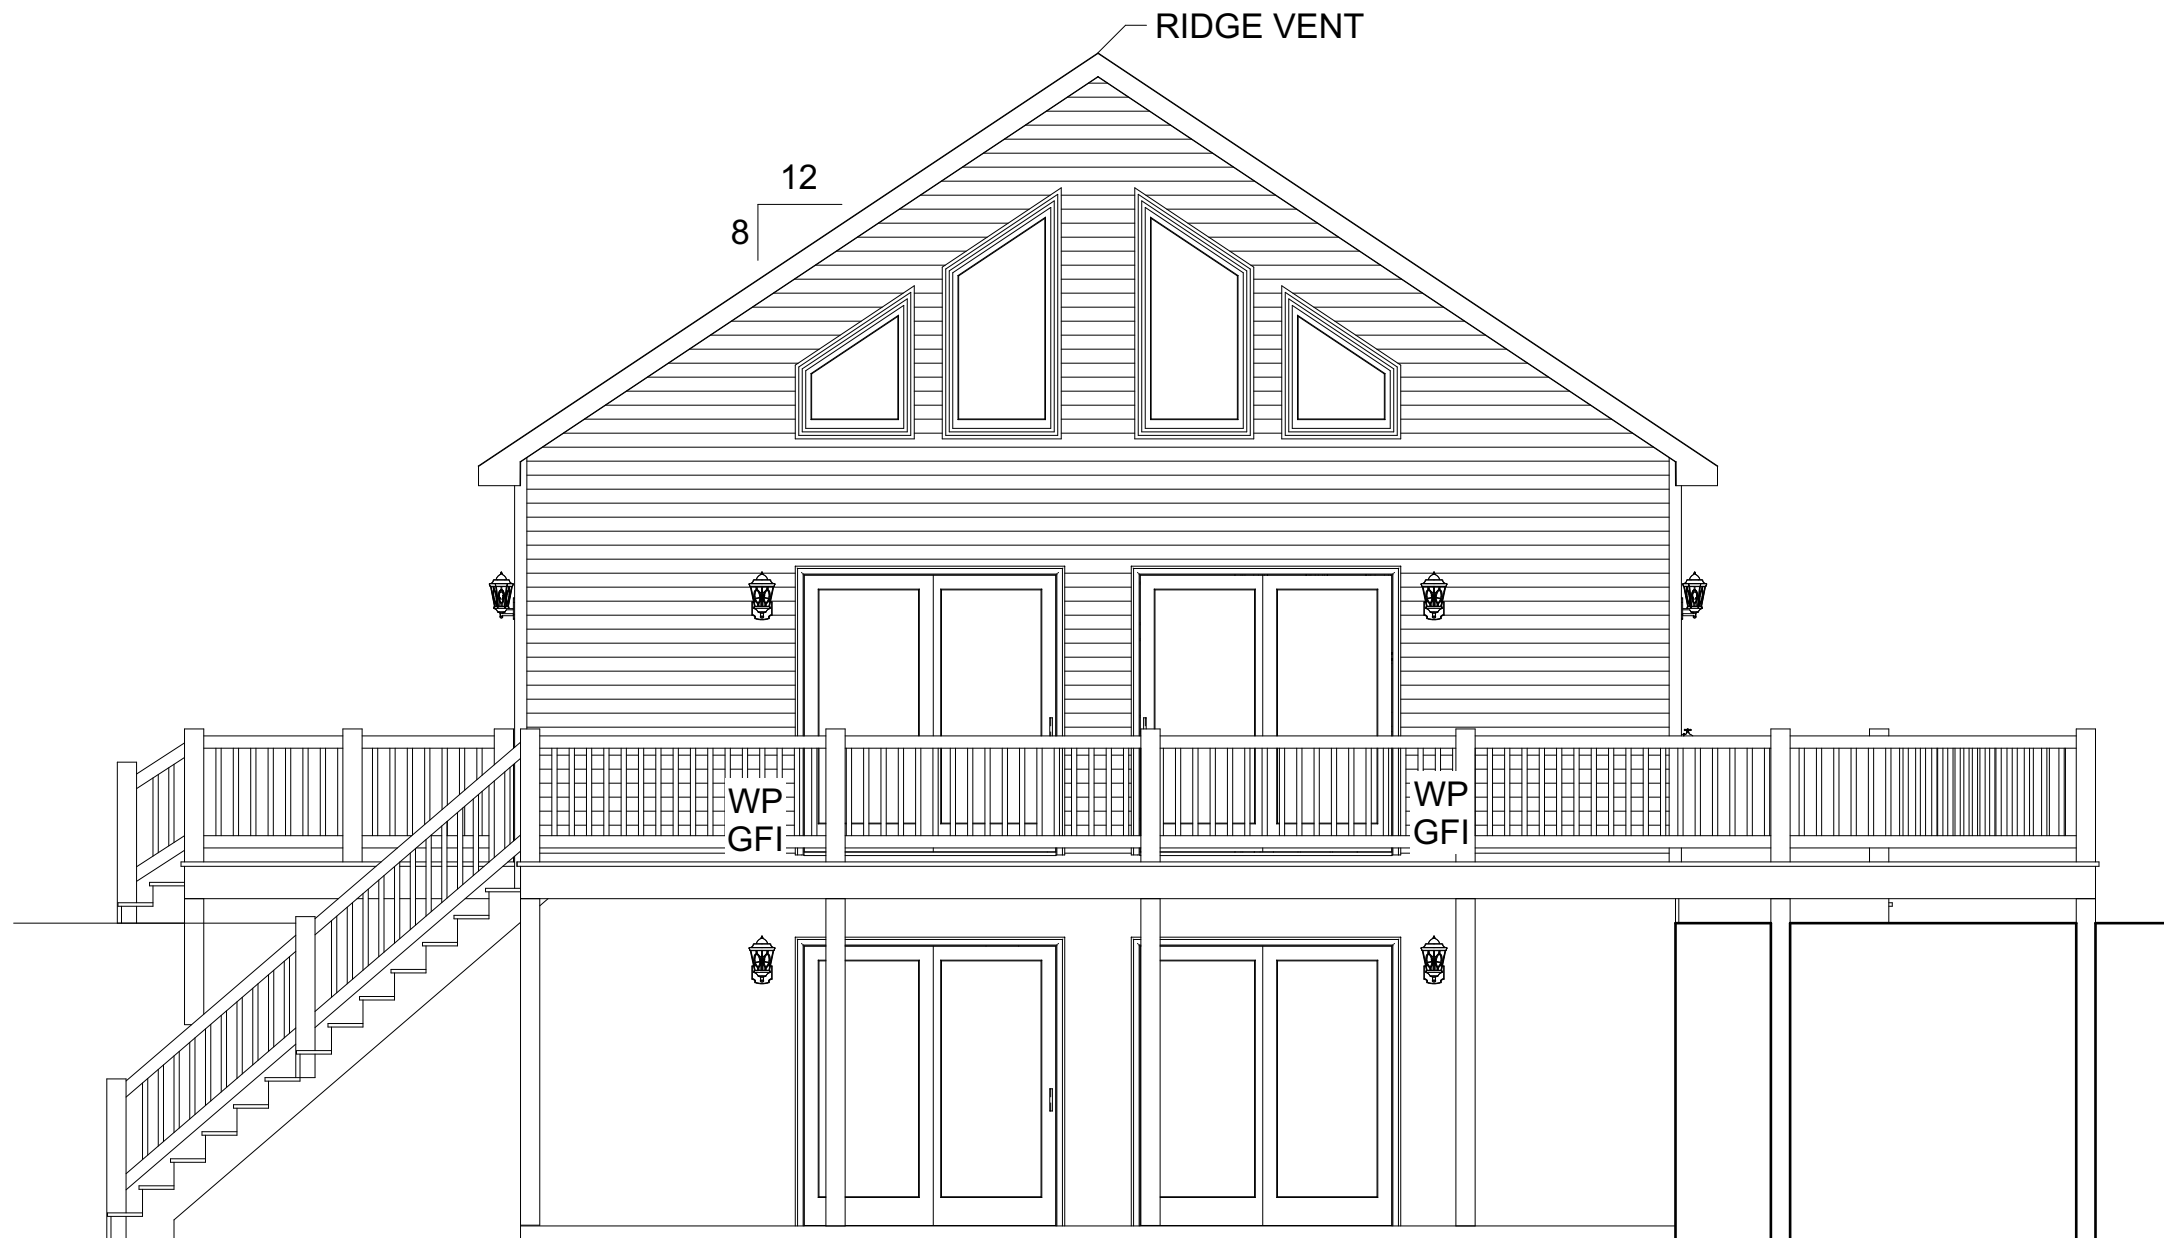

**RIGHT ELEVATION**

REVISION:	DATE:	BY:	REVISION:	DATE:	BY:
0	08/22/2023	SC	5	09/26/2023	SC
1	08/23/2023	SC	6	09/29/2023	SC
2	09/01/2023	SC	7	10/25/2023	SC
3	09/09/2023	SC			
4	09/20/2023	SC			

**ELEVATION**

CUSTOMER:  
ADDRESS:

**impresa**  
MODULAR  
1586 WINCHESTER AVE.  
MARTINSBURG, WV 25405  
FAX: 877-419-2505  
WWW.IMPRESAMODULAR.COM

SCALE:  
N.T.S.  
SHEET:  
**2.3**