

- NOTES:**
1. 2x6 EXTERIOR WALLS EXCEPT AS NOTED.
 2. 2x4 INTERIOR WALLS EXCEPT AS NOTED.
 3. 8'-0" CEILING HEIGHT.
 4. 7/12 NON-STORAGE ROOF EXCEPT AS NOTED.

- COLORS:**
1. ROOF SHINGLE: FOX HOLLOW GRAY
 2. SIDING: WEDGEWOOD BLUE
 3. WINDOW SHUTTERS: GREEN
 4. KITCHEN CABINETS: RECESSED PANEL WITH SLAB FRONT DRAWERS / NATURAL
 5. KITCHEN COUNTERTOPS: FORMICA BUTTERUM GRANITE

FLOOR AREA: 1,725 SQ.FT.

PORCH: 12.5 SQ.FT.

| REVISION: | DATE: | BY: | REVISION: | DATE: | BY: |
|-----------|------------|-----|-----------|-------|-----|
| 0 | 05/02/2024 | SC | | | |
| 1 | 05/03/2024 | SC | | | |
| 2 | 05/06/2024 | SC | | | |
| 3 | 05/08/2024 | SC | | | |

FLOOR PLAN

CUSTOMER: _____
 ADDRESS: _____


impresa
MODULAR

1586 WINCHESTER AVE.
 MARTINSBURG, WV 25405
 FAX: 877-419-2505
 WWW.IMPRESAMODULAR.COM

SCALE:
3/16"=1'-0"

SHEET:

| ELECTRICAL LEGEND | |
|-------------------|------------------------------------------------|
| | ELECTRIC PANEL |
| | METER |
| | LIGHT SWITCH |
| | 3 WAY LIGHT SWITCH |
| | 4 WAY LIGHT SWITCH |
| | SINGLE DIMMER LIGHT SWITCH |
| | 3 WAY DIMMER LIGHT SWITCH |
| | 110V DUPLEX RECEPTACLE |
| | 110V DUPLEX SPLIT RECEPTACLE |
| | EXTERIOR WP GFI OUTLET |
| | 220V DUPLEX RECEPTACLE |
| | CEILING MOUNTED OUTLET |
| | FLOOR OUTLET |
| | QUADRUPLEX RECEPTACLE |
| | STANDARD CEILING LIGHT |
| | PENDANT LIGHT |
| | RECESSED LIGHT |
| | UNDER CABINET LIGHT |
| | CHANDELIER LIGHT |
| | VANITY WALL MOUNT LIGHT |
| | WALL SCONCE |
| | EXTERIOR WALL LIGHT |
| | SPOT LIGHT |
| | MOTION LIGHT |
| | FLUORESCENT |
| | JUNCTION BOX |
| | EXHAUST FAN |
| | EXHAUST FAN / LIGHT |
| | EXHAUST FAN, LIGHT & HEAT |
| | CEILING FAN OR FAN/LIGHT -SEE PLAN FOR INFO |
| | SMOKE DETECTOR |
| | CO/SMOKE DETECTOR |
| | TV |
| | PHONE |
| | HUMIDISTAT |
| | THERMOSTAT |
| | ETHERNET |
| | CABLE |
| | DOOR CHIME |
| | DOORBELL |
| | EMERGENCY LIGHTING |
| | EXIT SIGN |

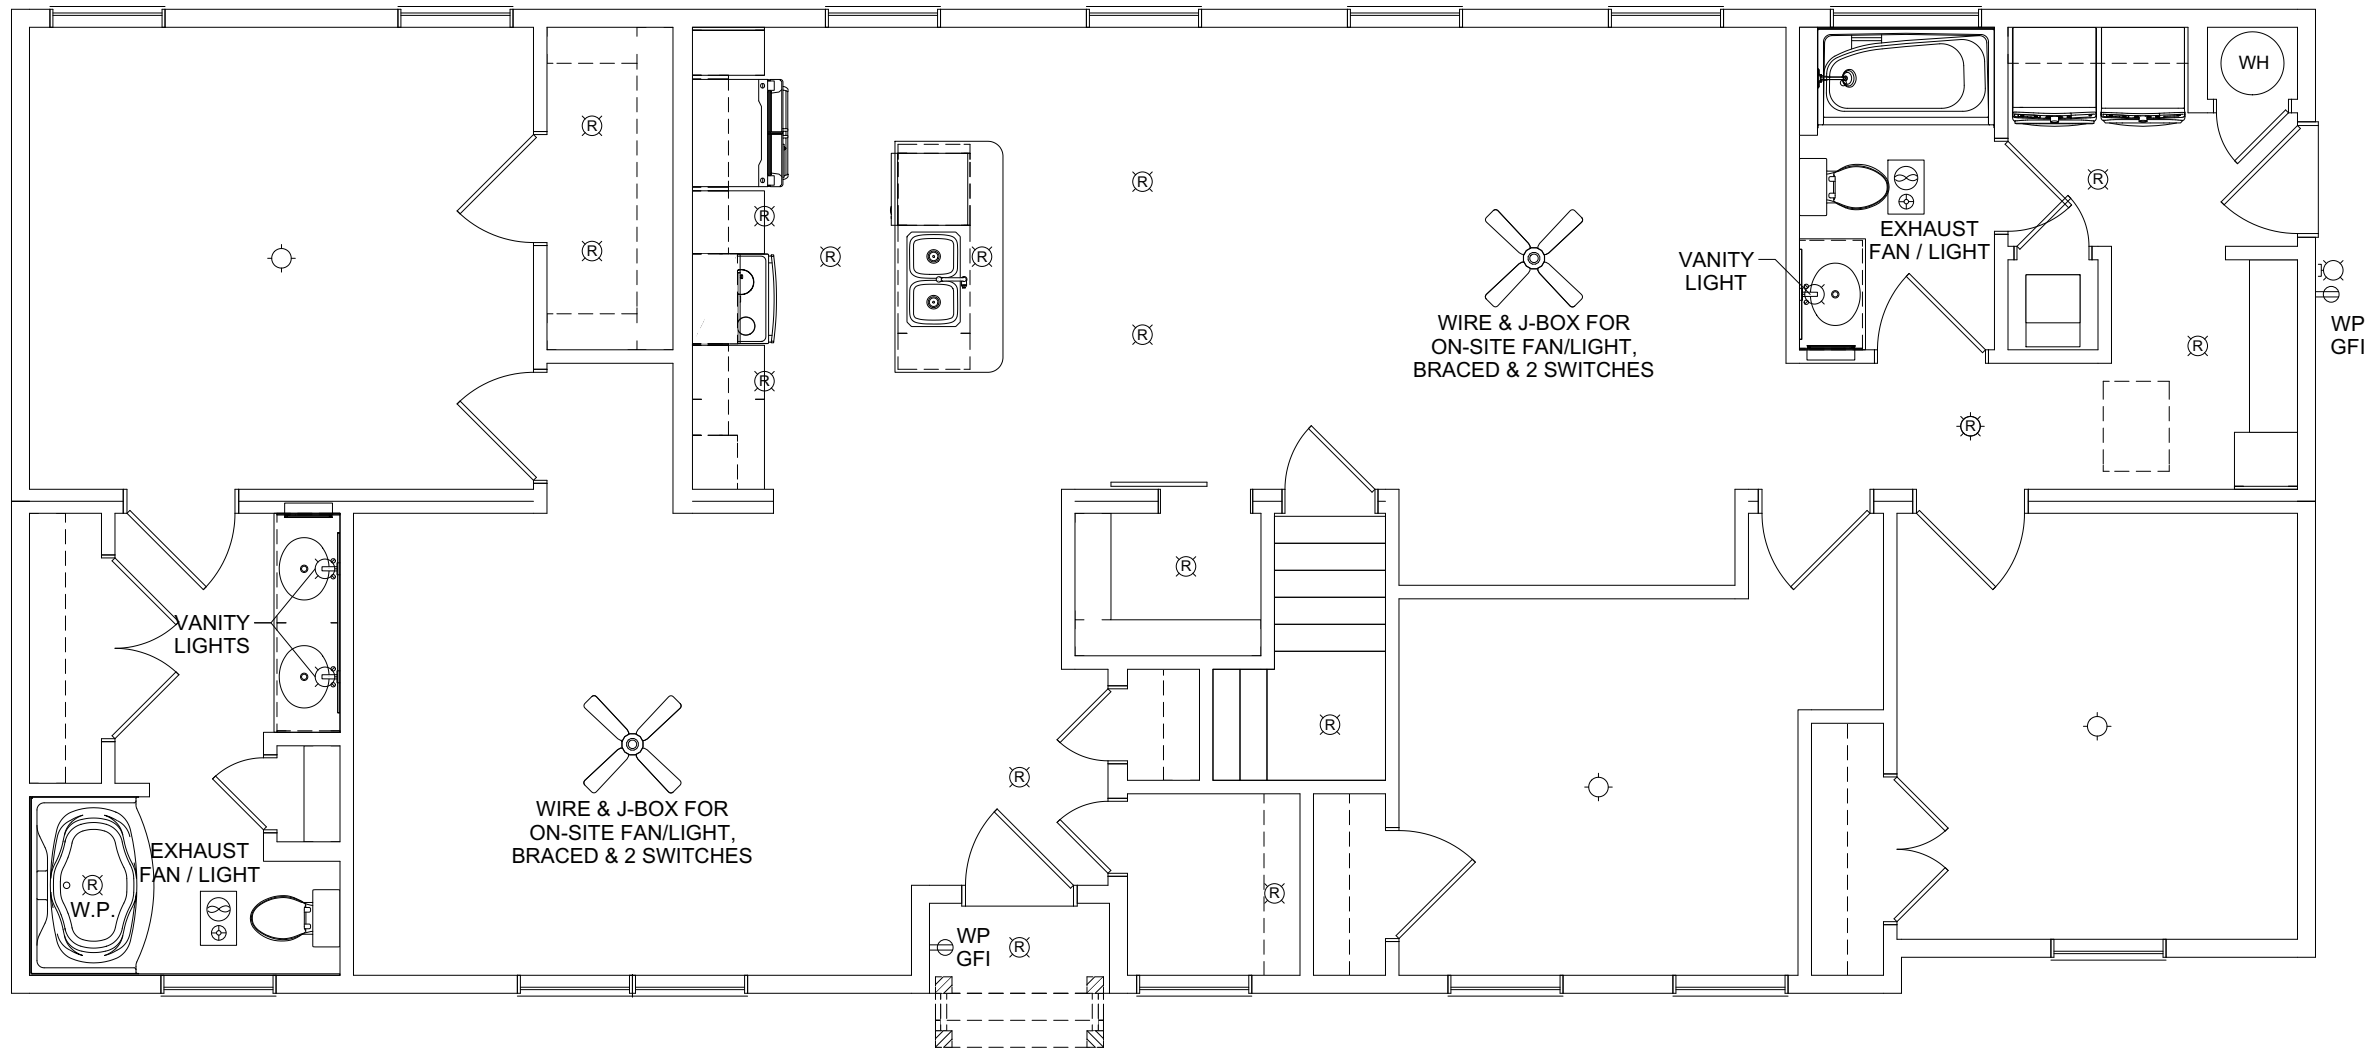

| REVISION: | DATE: | BY: | REVISION: | DATE: | BY: |
|-----------|------------|-----|-----------|-------|-----|
| 0 | 05/02/2024 | SC | | | |
| 1 | 05/03/2024 | SC | | | |
| 2 | 05/06/2024 | SC | | | |
| 3 | 05/08/2024 | SC | | | |

**ELECTRICAL
PLAN**

CUSTOMER: _____
ADDRESS: _____

impresa
MODULAR


1586 WINCHESTER AVE.
MARTINSBURG, WV 25405
FAX: 877-419-2505
WWW.IMPRESAMODULAR.COM

SCALE:
3/16"=1'-0"


SHEET:

1.2

DISCLAIMER: THESE DRAWINGS ARE ARTISTS RENDERINGS ONLY AND FINAL PROJECT MAY NOT BE IDENTICAL TO THAT SHOWN HERE. PROPRIETARY WORK PRODUCT AND PROPERTY OF EXPRESS HOMES, INC. DBA IMPRESA MODULAR AND DEVELOPED FOR THE EXCLUSIVE USE OF IMPRESA MODULAR. USE OF THESE DRAWINGS AND CONCEPTS CONTAINED THEREIN WITHOUT WRITTEN PERMISSION OF IMPRESA MODULAR IS PROHIBITED.

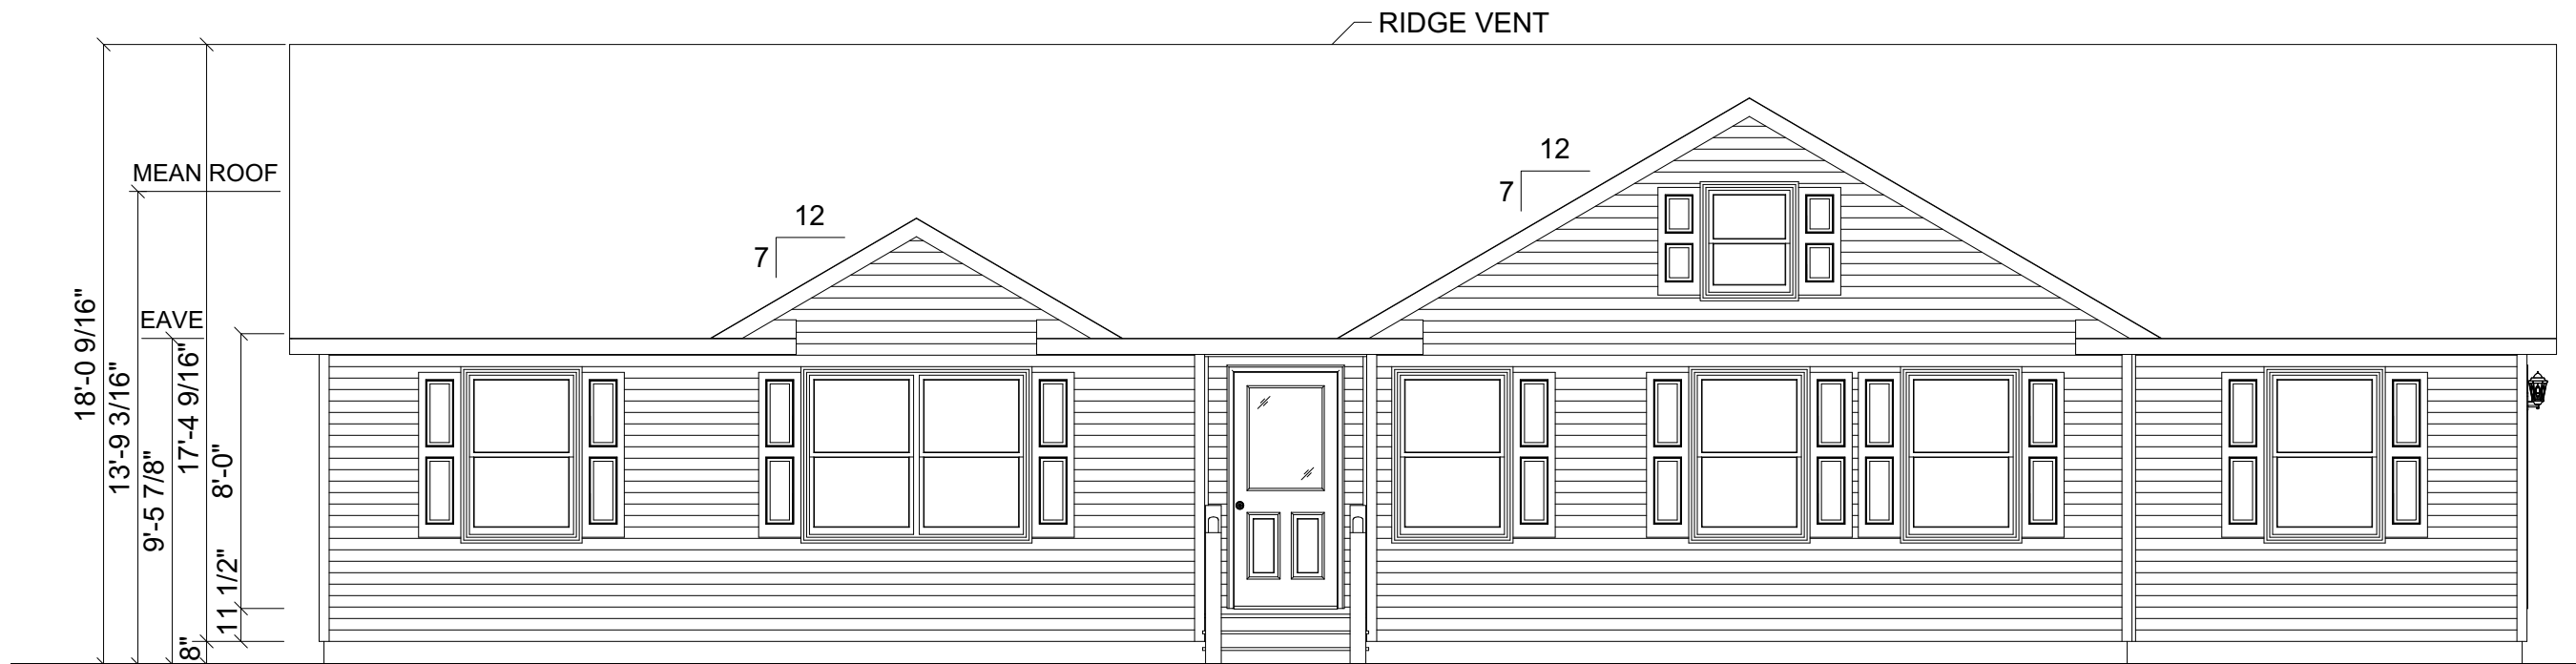

FRONT ELEVATION

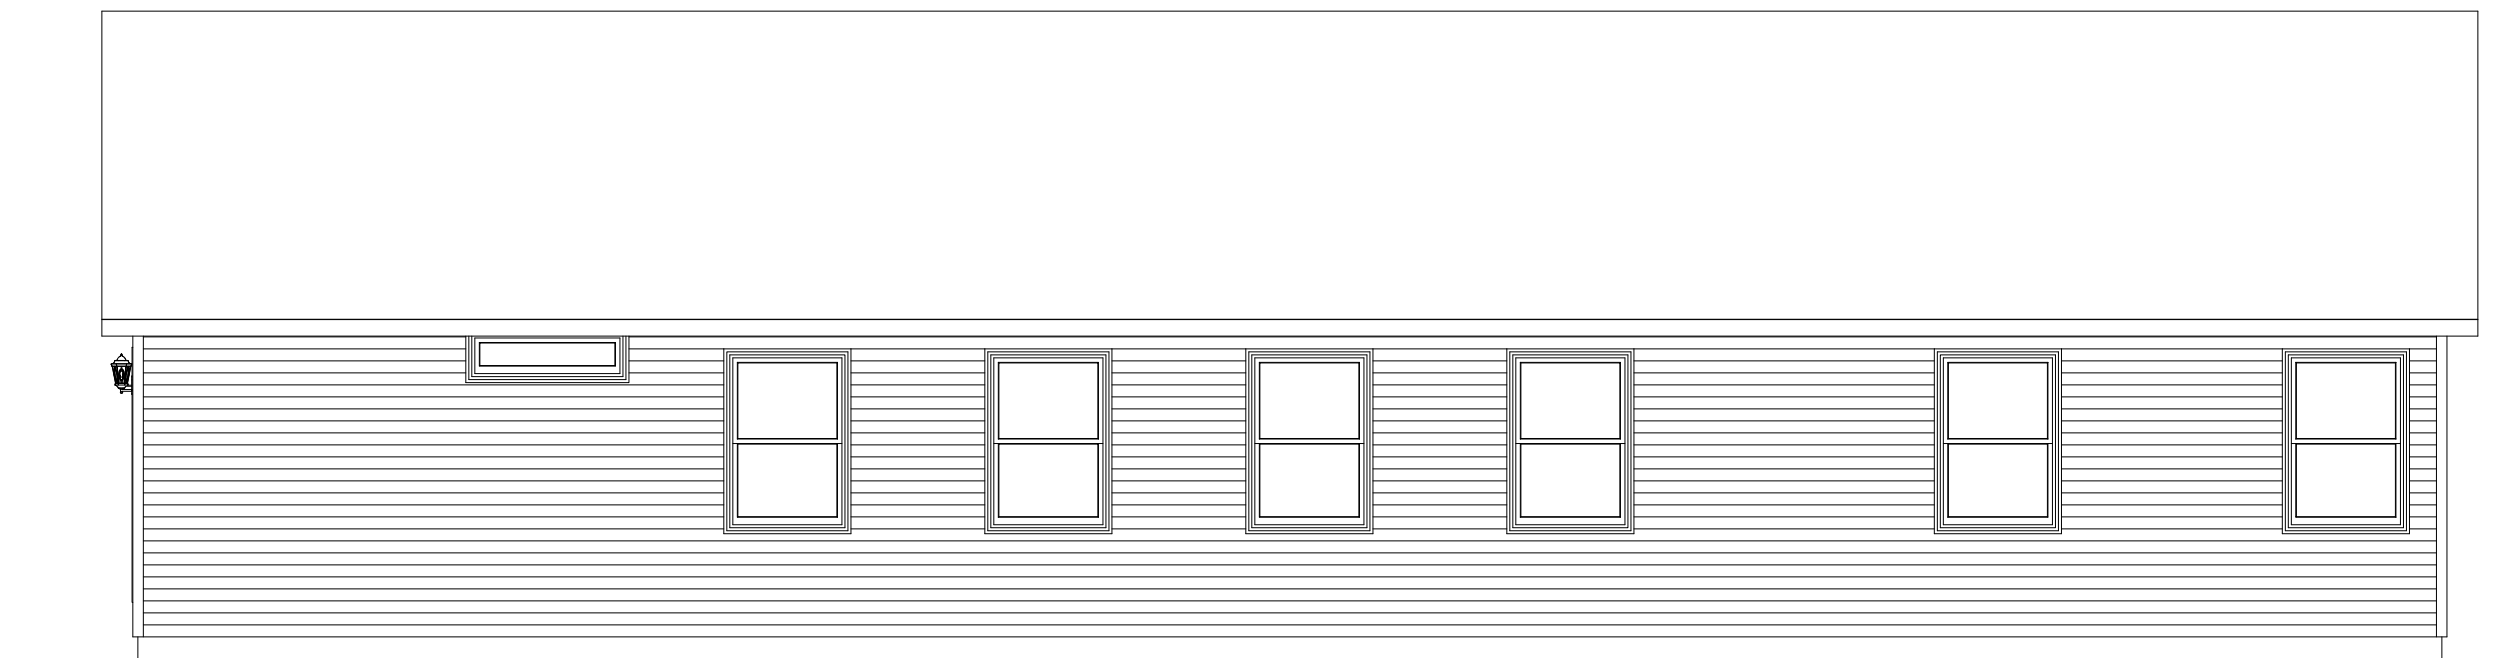

REAR ELEVATION

| REVISION: | DATE: | BY: | REVISION: | DATE: | BY: |
|-----------|------------|-----|-----------|-------|-----|
| 0 | 05/02/2024 | SC | | | |
| 1 | 05/03/2024 | SC | | | |
| 2 | 05/06/2024 | SC | | | |
| 3 | 05/08/2024 | SC | | | |

ELEVATIONS


CUSTOMER:
ADDRESS:

impresa
MODULAR
1586 WINCHESTER AVE.
MARTINSBURG, WV 25405
FAX: 877-419-2505
WWW.IMPRESAMODULAR.COM


SCALE:
3/16"=1'-0"

SHEET:
2.0

DISCLAIMER: THESE DRAWINGS ARE ARTISTS RENDERINGS ONLY AND FINAL PROJECT MAY NOT BE IDENTICAL TO THAT SHOWN HERE. PROPRIETARY WORK PRODUCT AND PROPERTY OF EXPRESS HOMES, INC. DBA IMPRESA MODULAR AND DEVELOPED FOR THE EXCLUSIVE USE OF IMPRESA MODULAR. USE OF THESE DRAWINGS AND CONCEPTS CONTAINED THEREIN WITHOUT WRITTEN PERMISSION OF IMPRESA MODULAR IS PROHIBITED.

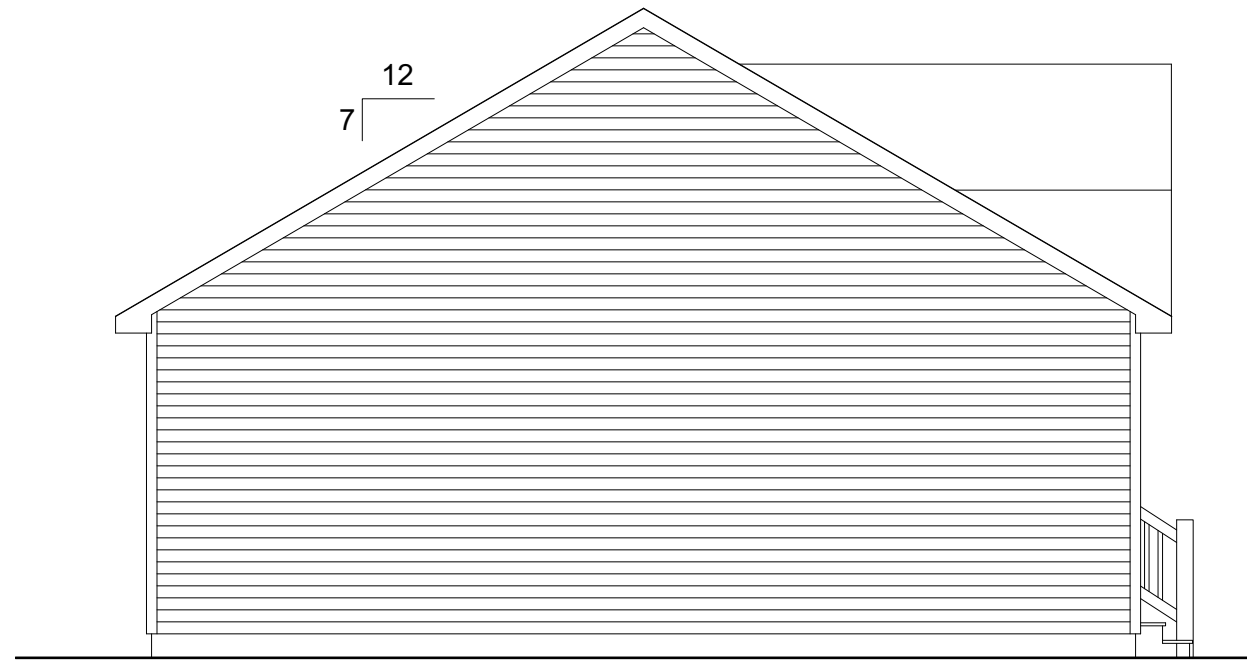

LEFT ELEVATION

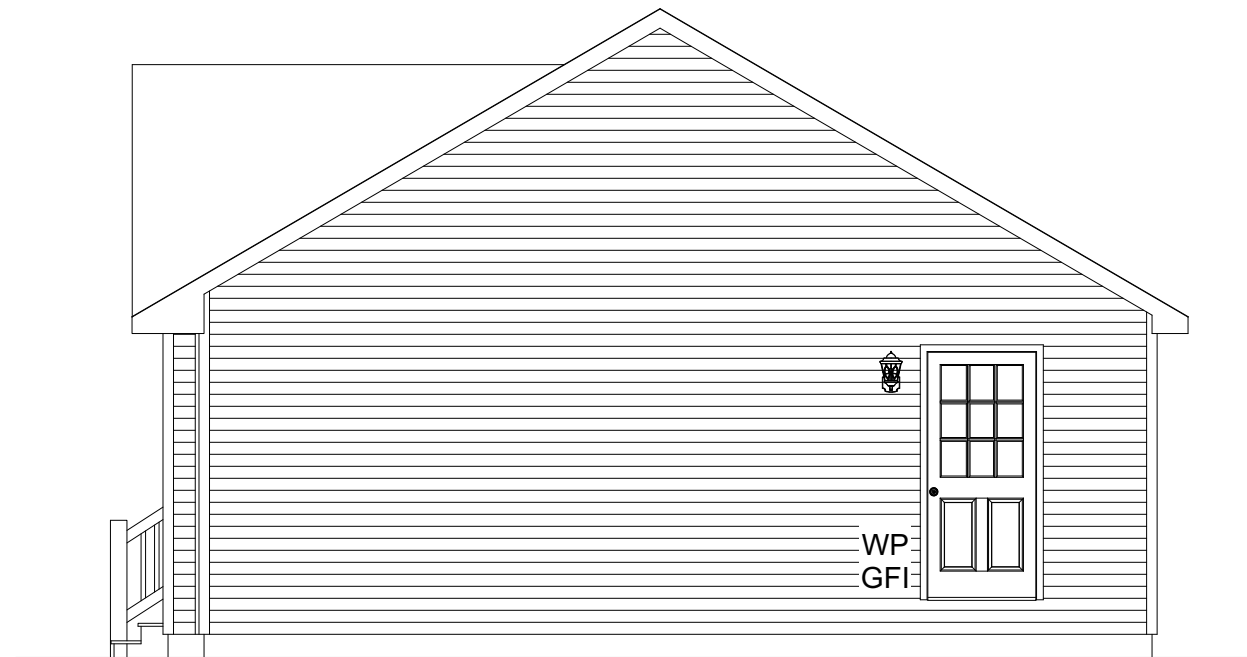

ACCESS TO GRADE
ON-SITE BY OTHERS

RIGHT ELEVATION

| REVISION: | DATE: | BY: | REVISION: | DATE: | BY: |
|-----------|------------|-----|-----------|-------|-----|
| 0 | 05/02/2024 | SC | | | |
| 1 | 05/03/2024 | SC | | | |
| 2 | 05/06/2024 | SC | | | |
| 3 | 05/08/2024 | SC | | | |

ELEVATIONS

CUSTOMER:
ADDRESS:




impresa
MODULAR
1586 WINCHESTER AVE.
MARTINSBURG, WV 25405
FAX: 877-419-2505
WWW.IMPRESAMODULAR.COM

SCALE:
3/16"=1'-0"

SHEET:

2.1

DISCLAIMER: THESE DRAWINGS ARE ARTISTS RENDERINGS ONLY AND FINAL PROJECT MAY NOT BE IDENTICAL TO THAT SHOWN HERE. PROPRIETARY WORK PRODUCT AND PROPERTY OF EXPRESS HOMES, INC. DBA IMPRESA MODULAR AND DEVELOPED FOR THE EXCLUSIVE USE OF IMPRESA MODULAR. USE OF THESE DRAWINGS AND CONCEPTS CONTAINED THEREIN WITHOUT WRITTEN PERMISSION OF IMPRESA MODULAR IS PROHIBITED.

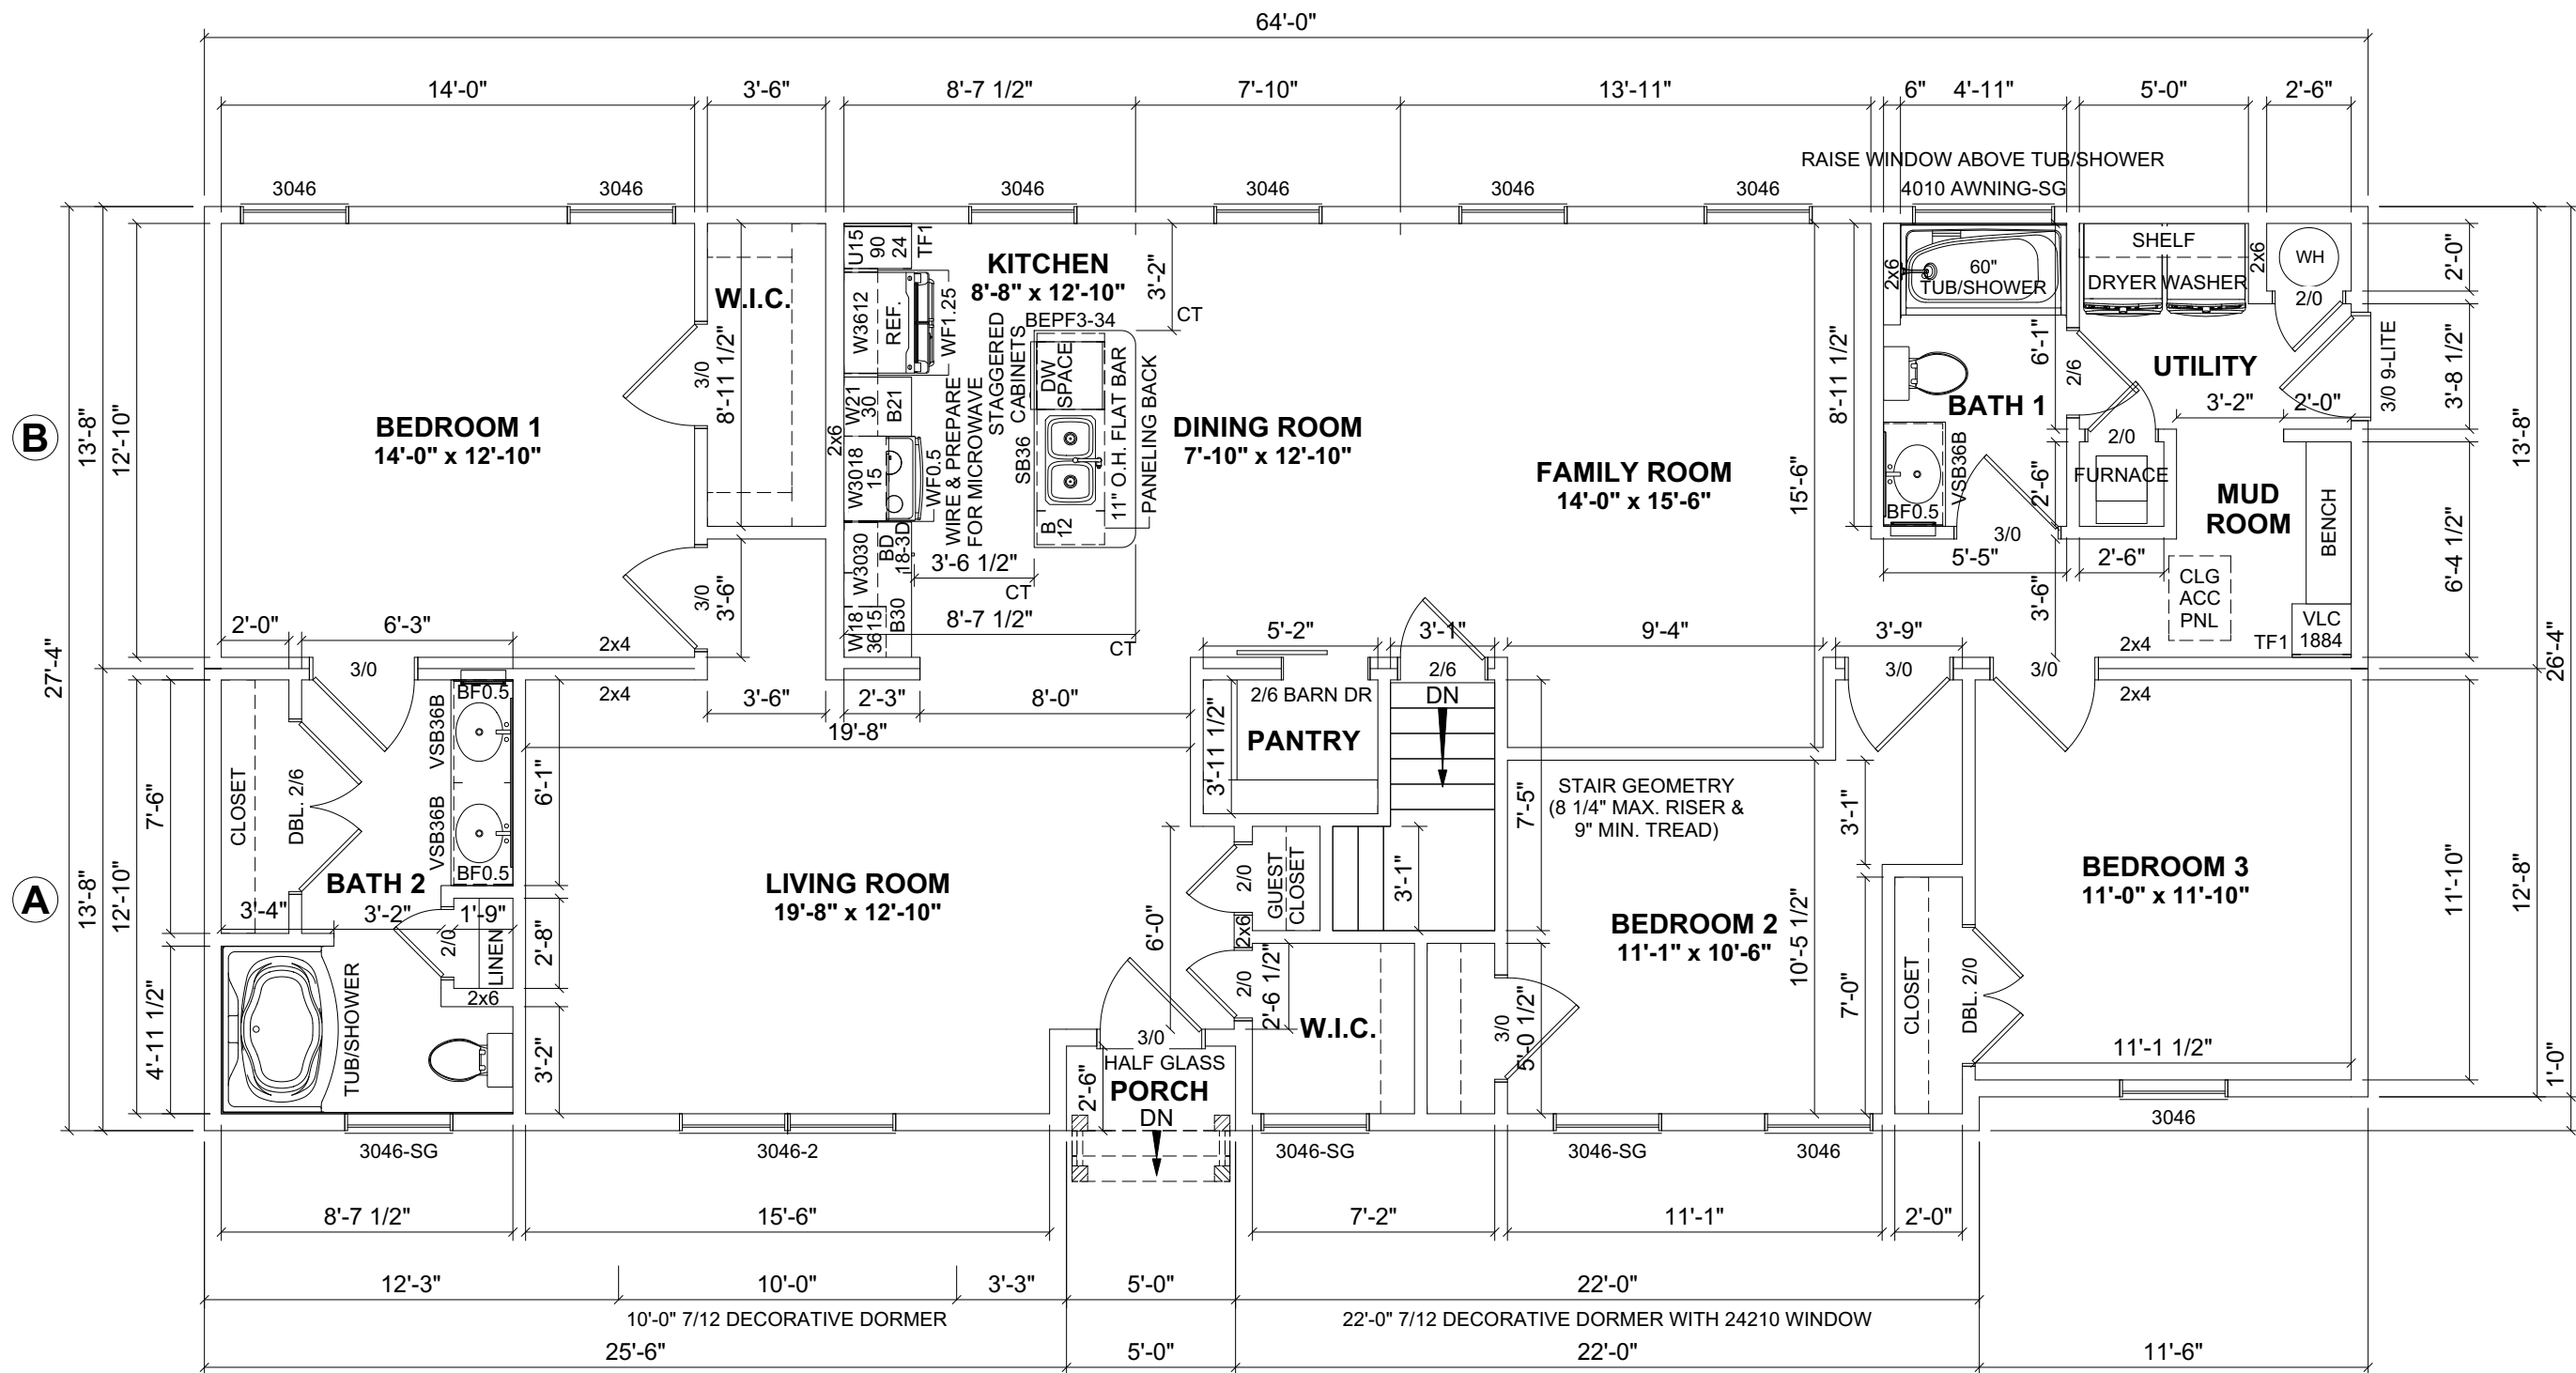

- NOTES:**
1. 2x6 EXTERIOR WALLS EXCEPT AS NOTED.
 2. 2x4 INTERIOR WALLS EXCEPT AS NOTED.
 3. 8'-0" CEILING HEIGHT.
 4. 7/12 NON-STORAGE ROOF EXCEPT AS NOTED.

- COLORS:**
1. ROOF SHINGLE: FOX HOLLOW GRAY
 2. SIDING: WEDGEWOOD BLUE
 3. WINDOW SHUTTERS: GREEN
 4. KITCHEN CABINETS: RECESSED PANEL WITH SLAB FRONT DRAWERS / NATURAL
 5. KITCHEN COUNTERTOPS: FORMICA BUTTERUM GRANITE

FLOOR AREA: 1,725 SQ.FT.

PORCH: 12.5 SQ.FT.

| REVISION: | DATE: | BY: | REVISION: | DATE: | BY: |
|-----------|------------|-----|-----------|-------|-----|
| 0 | 05/02/2024 | SC | | | |
| 1 | 05/03/2024 | SC | | | |
| 2 | 05/06/2024 | SC | | | |
| 3 | 05/08/2024 | SC | | | |

FLOOR PLAN

CUSTOMER: _____
 ADDRESS: _____

impresa
MODULAR

1586 WINCHESTER AVE.
 MARTINSBURG, WV 25405
 FAX: 877-419-2505
 WWW.IMPRESAMODULAR.COM

SCALE:
 3/16"=1'-0"

SHEET:

3.0

DISCLAIMER: THESE DRAWINGS ARE ARTISTS RENDERINGS ONLY AND FINAL PROJECT MAY NOT BE IDENTICAL TO THAT SHOWN HERE. PROPRIETARY WORK PRODUCT AND PROPERTY OF EXPRESS HOMES, INC. DBA IMPRESA MODULAR AND DEVELOPED FOR THE EXCLUSIVE USE OF IMPRESA MODULAR. USE OF THESE DRAWINGS AND CONCEPTS CONTAINED THEREIN WITHOUT WRITTEN PERMISSION OF IMPRESA MODULAR IS PROHIBITED.