


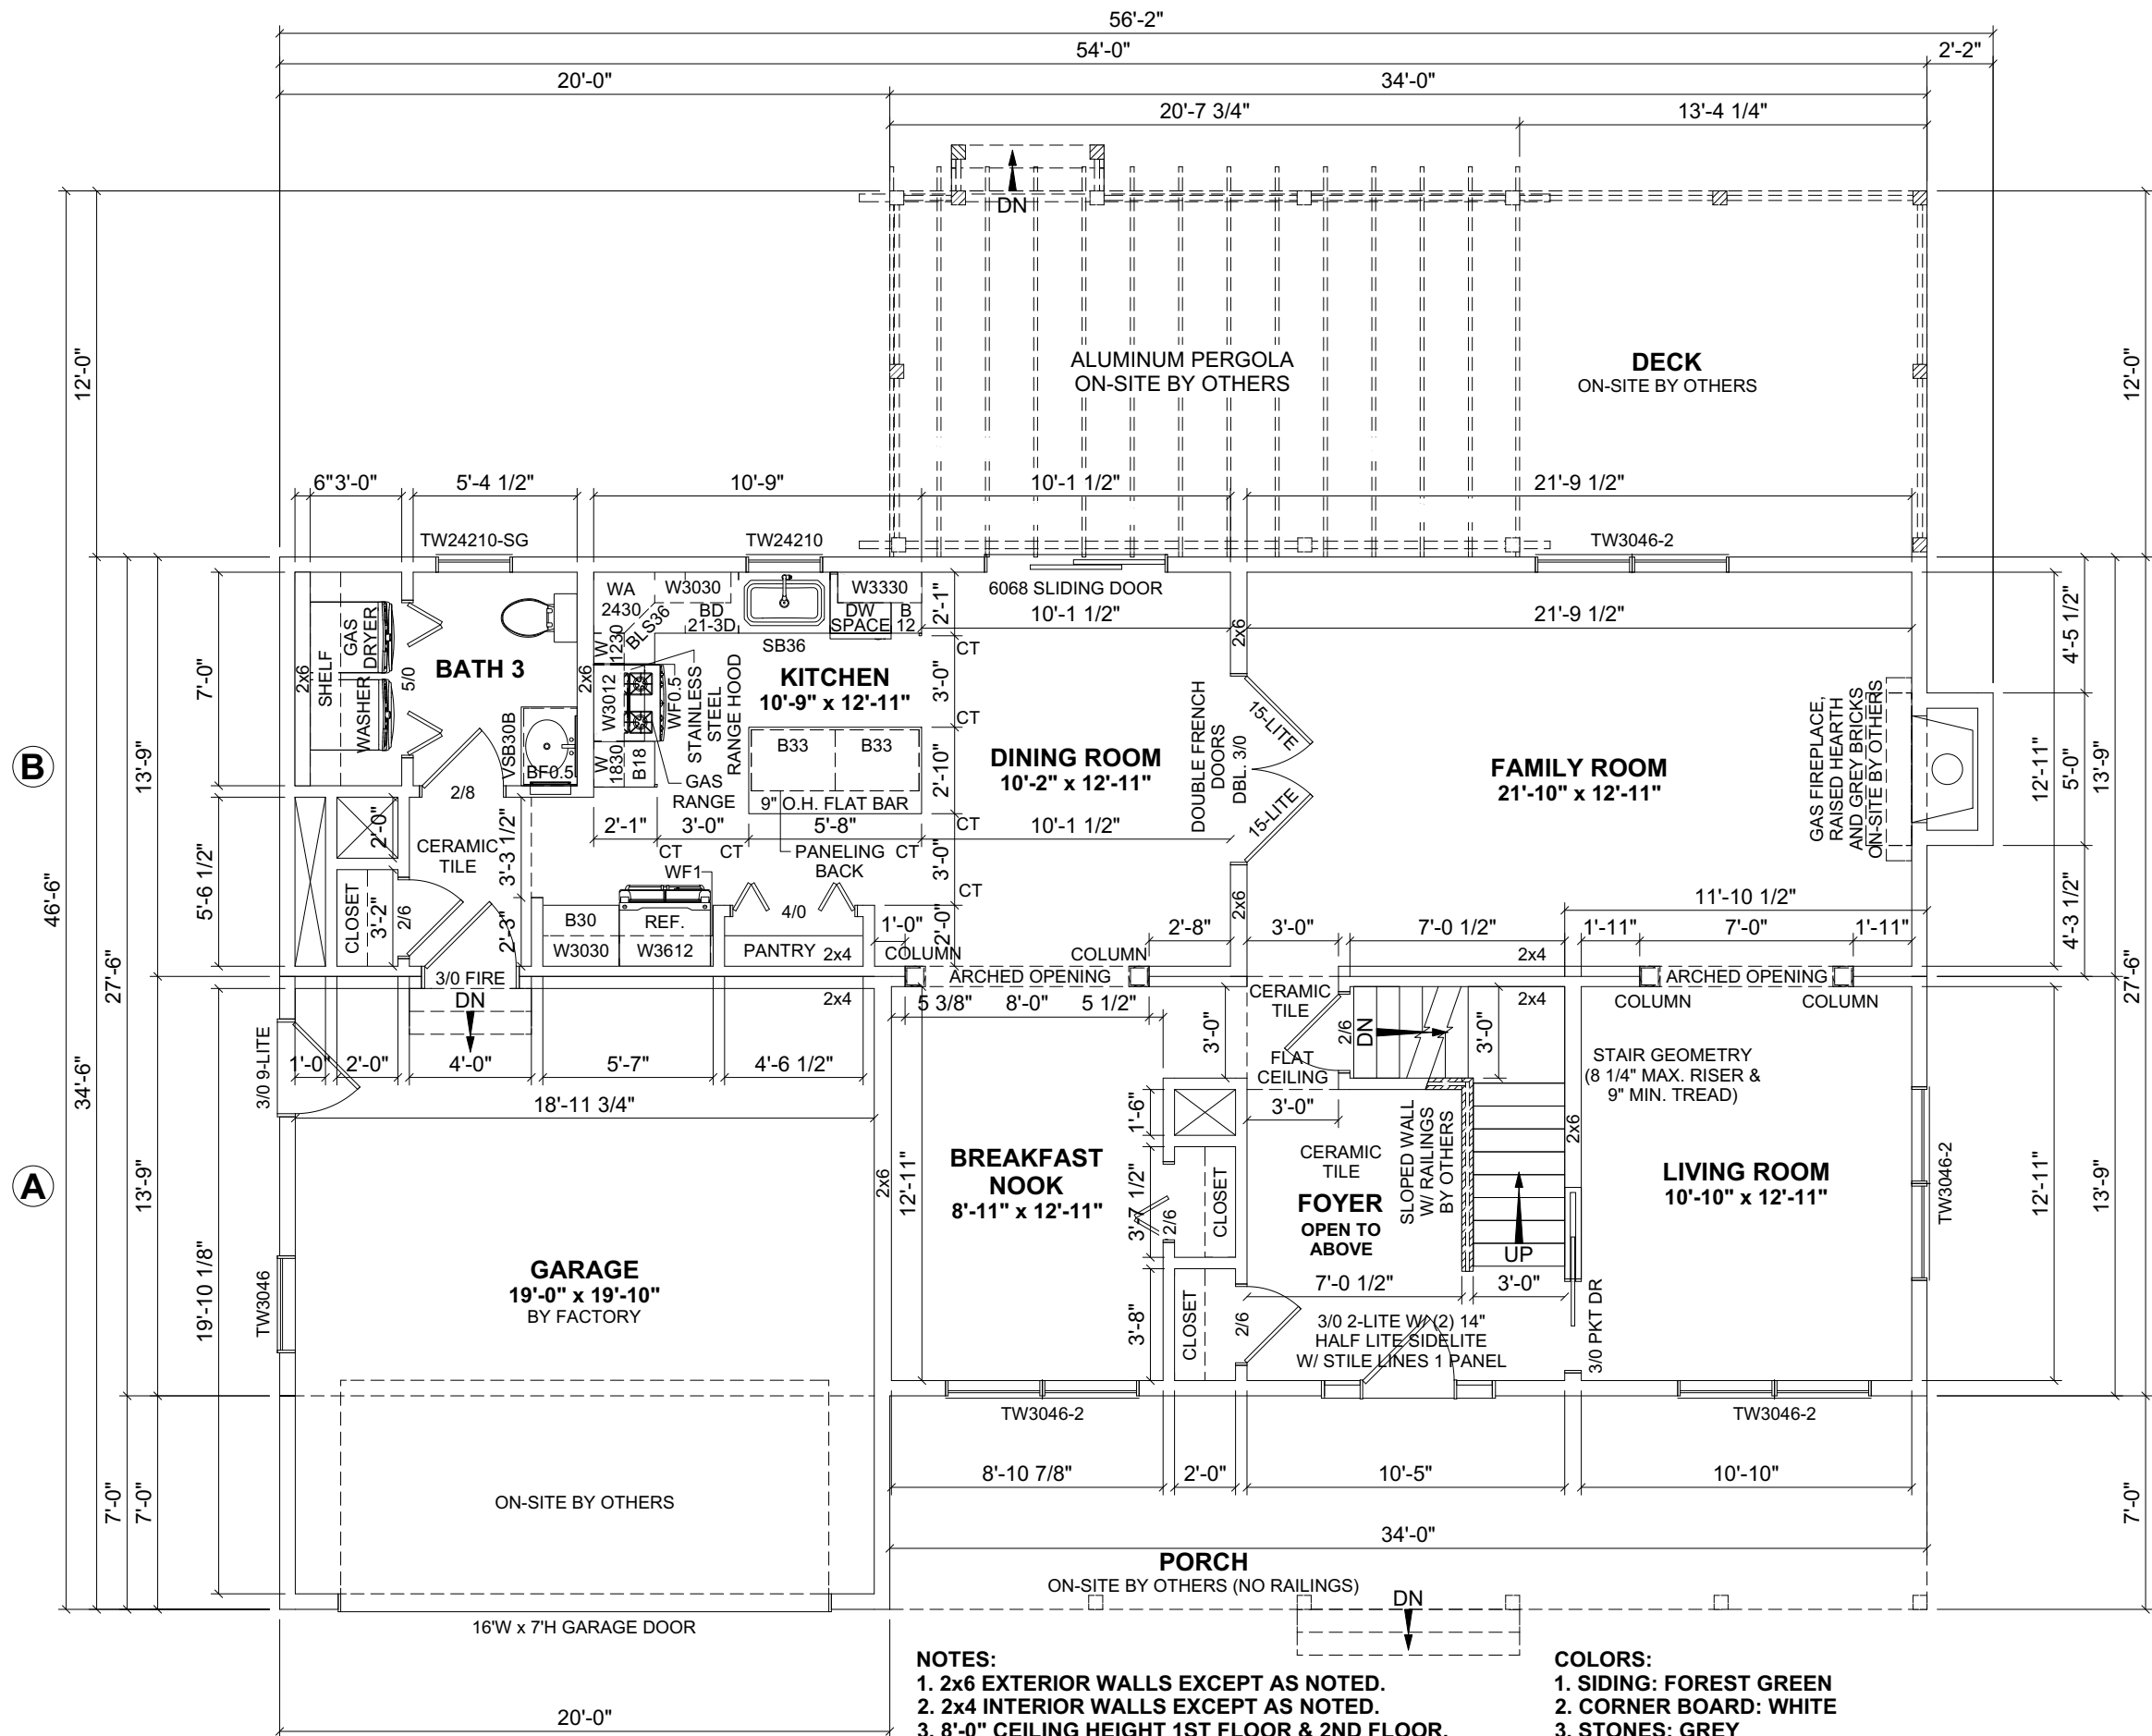

- NOTES:**
1. 2x6 EXTERIOR WALLS EXCEPT AS NOTED.
 2. 2x4 INTERIOR WALLS EXCEPT AS NOTED.
 3. 8'-0" CEILING HEIGHT 1ST FLOOR & 2ND FLOOR.
 4. 7/12 STORAGE ROOF EXCEPT AS NOTED.
 5. ANDERSEN 400 SERIES TILT-WASH WINDOWS.

- COLORS:**
1. SIDING: FOREST GREEN
 2. CORNER BOARD: WHITE
 3. STONES: GREY
 4. WINDOW EXTERIOR: ALUMINUM STAINED OAK
 5. WINDOW INTERIOR: WOOD

1ST FLOOR: 1,221 SQ.FT.
2ND FLOOR: 1,425 SQ.FT.
TOTAL AREA: 2,646 SQ.FT.

GARAGE: 415 SQ.FT.
PORCH: 238 SQ.FT.
DECK: 408 SQ.FT.
TOTAL AREA: 646 SQ.FT.

REVISION:	DATE:	BY:	REVISION:	DATE:	BY:
0	01/24/2024	SC	5	05/10/2024	SC
1	01/25/2024	SC			
2	03/10/2024	SC			
3	04/07/2024	SC			
4	04/27/2024	SC			

FIRST FLOOR PLAN

CUSTOMER: _____

ADDRESS: _____

impresa
MODULAR


1586 WINCHESTER AVE.
MARTINSBURG, WV 25405
FAX: 877-419-2505
WWW.IMPRESAMODULAR.COM

SCALE: _____

N.T.S.

SHEET: _____

DISCLAIMER: THESE DRAWINGS ARE ARTISTS RENDERINGS ONLY AND FINAL PROJECT MAY NOT BE IDENTICAL TO THAT SHOWN HERE. PROPRIETARY WORK PRODUCT AND PROPERTY OF EXPRESS HOMES, INC. DBA IMPRESA MODULAR AND DEVELOPED FOR THE EXCLUSIVE USE OF IMPRESA MODULAR. USE OF THESE DRAWINGS AND CONCEPTS CONTAINED THEREIN WITHOUT WRITTEN PERMISSION OF IMPRESA MODULAR IS PROHIBITED.

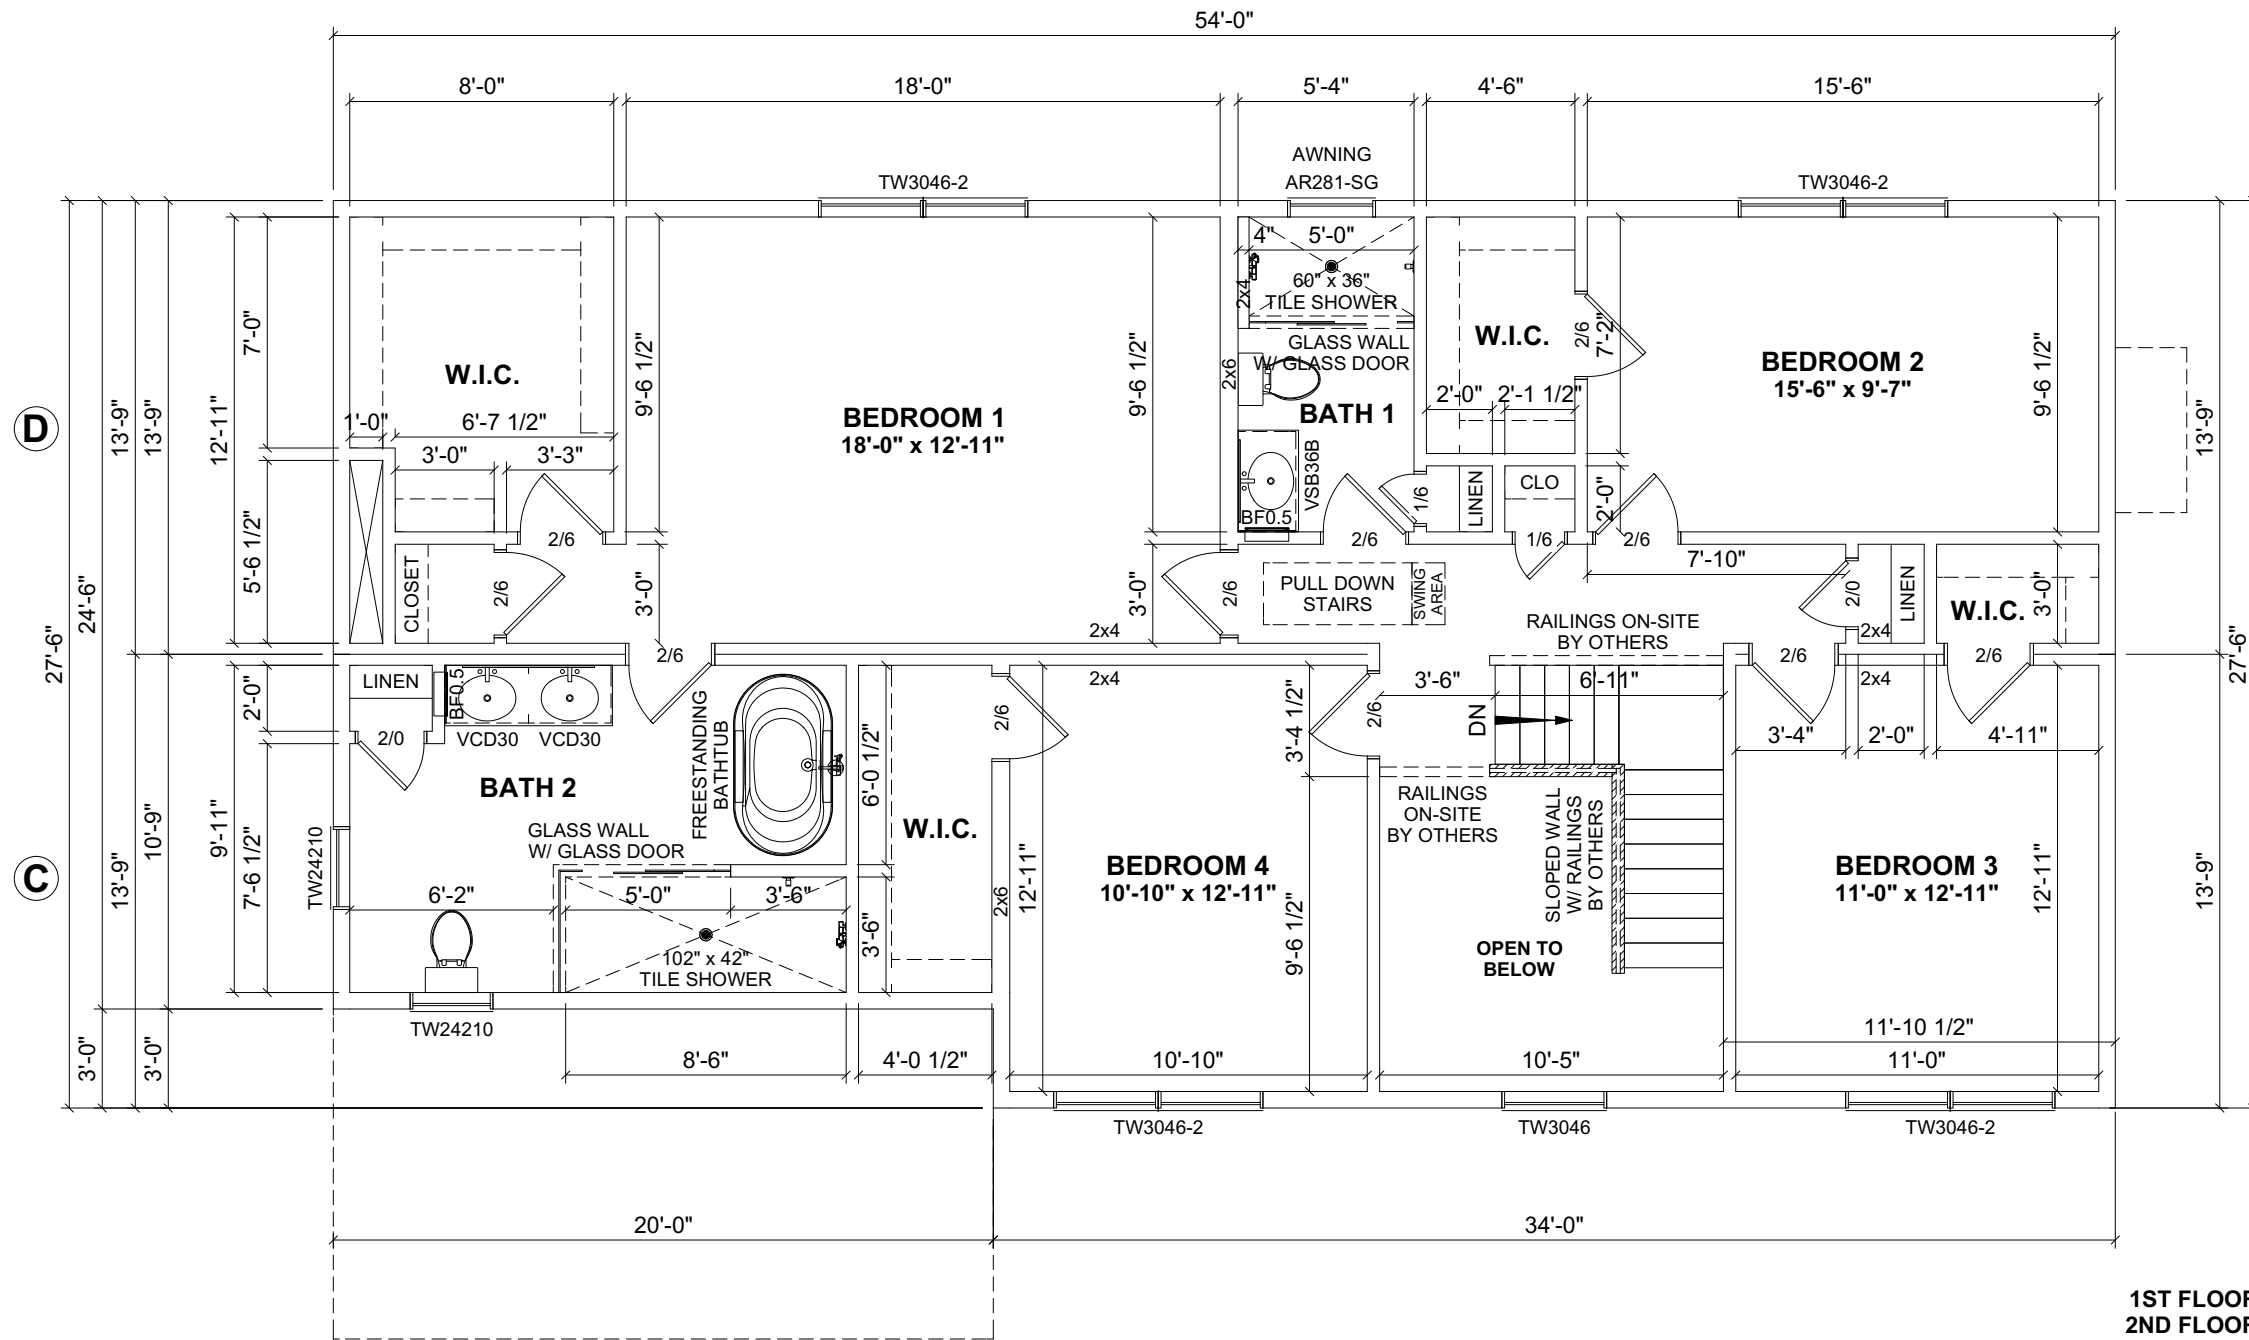

1ST FLOOR: 1,221 SQ.FT.
2ND FLOOR: 1,425 SQ.FT.
TOTAL AREA: 2,646 SQ.FT.

GARAGE: 415 SQ.FT.

PORCH: 238 SQ.FT.
DECK: 408 SQ.FT.
TOTAL AREA: 646 SQ.FT.

SECOND FLOOR PLAN

CUSTOMER:

ADDRESS:



SCALE:

N.T.S.


SHEET:

1.2

REVISION:	DATE:	BY:	REVISION:	DATE:	BY:
0	01/24/2024	SC	5	05/10/2024	SC
1	01/25/2024	SC			
2	03/10/2024	SC			
3	04/07/2024	SC			
4	04/27/2024	SC			

DISCLAIMER: THESE DRAWINGS ARE ARTISTS RENDERINGS ONLY AND FINAL PROJECT MAY NOT BE IDENTICAL TO THAT SHOWN HERE. PROPRIETARY WORK PRODUCT AND PROPERTY OF EXPRESS HOMES, INC. DBA IMPRESA MODULAR AND DEVELOPED FOR THE EXCLUSIVE USE OF IMPRESA MODULAR. USE OF THESE DRAWINGS AND CONCEPTS CONTAINED THEREIN WITHOUT WRITTEN PERMISSION OF IMPRESA MODULAR IS PROHIBITED.

ELECTRICAL LEGEND	
	ELECTRIC PANEL
	METER
	LIGHT SWITCH
	3 WAY LIGHT SWITCH
	4 WAY LIGHT SWITCH
	SINGLE DIMMER LIGHT SWITCH
	3 WAY DIMMER LIGHT SWITCH
	110V DUPLEX RECEPTACLE
	110V DUPLEX SPLIT RECEPTACLE
	EXTERIOR WP GFI OUTLET
	220V DUPLEX RECEPTACLE
	CEILING MOUNTED OUTLET
	FLOOR OUTLET
	QUADRUPLEX RECEPTACLE
	STANDARD CEILING LIGHT
	PENDANT LIGHT
	RECESSED LIGHT
	UNDER CABINET LIGHT
	CHANDELIER LIGHT
	VANITY WALL MOUNT LIGHT
	WALL SCONCE
	EXTERIOR WALL LIGHT
	SPOT LIGHT
	MOTION LIGHT
	FLUORESCENT
	JUNCTION BOX
	EXHAUST FAN
	EXHAUST FAN / LIGHT
	EXHAUST FAN, LIGHT & HEAT
	CEILING FAN OR FAN/LIGHT -SEE PLAN FOR INFO
	SMOKE DETECTOR
	CO/SMOKE DETECTOR
	TV
	PHONE
	HUMIDISTAT
	THERMOSTAT
	ETHERNET
	CABLE
	DOOR CHIME
	DOORBELL
	EMERGENCY LIGHTING
	EXIT SIGN

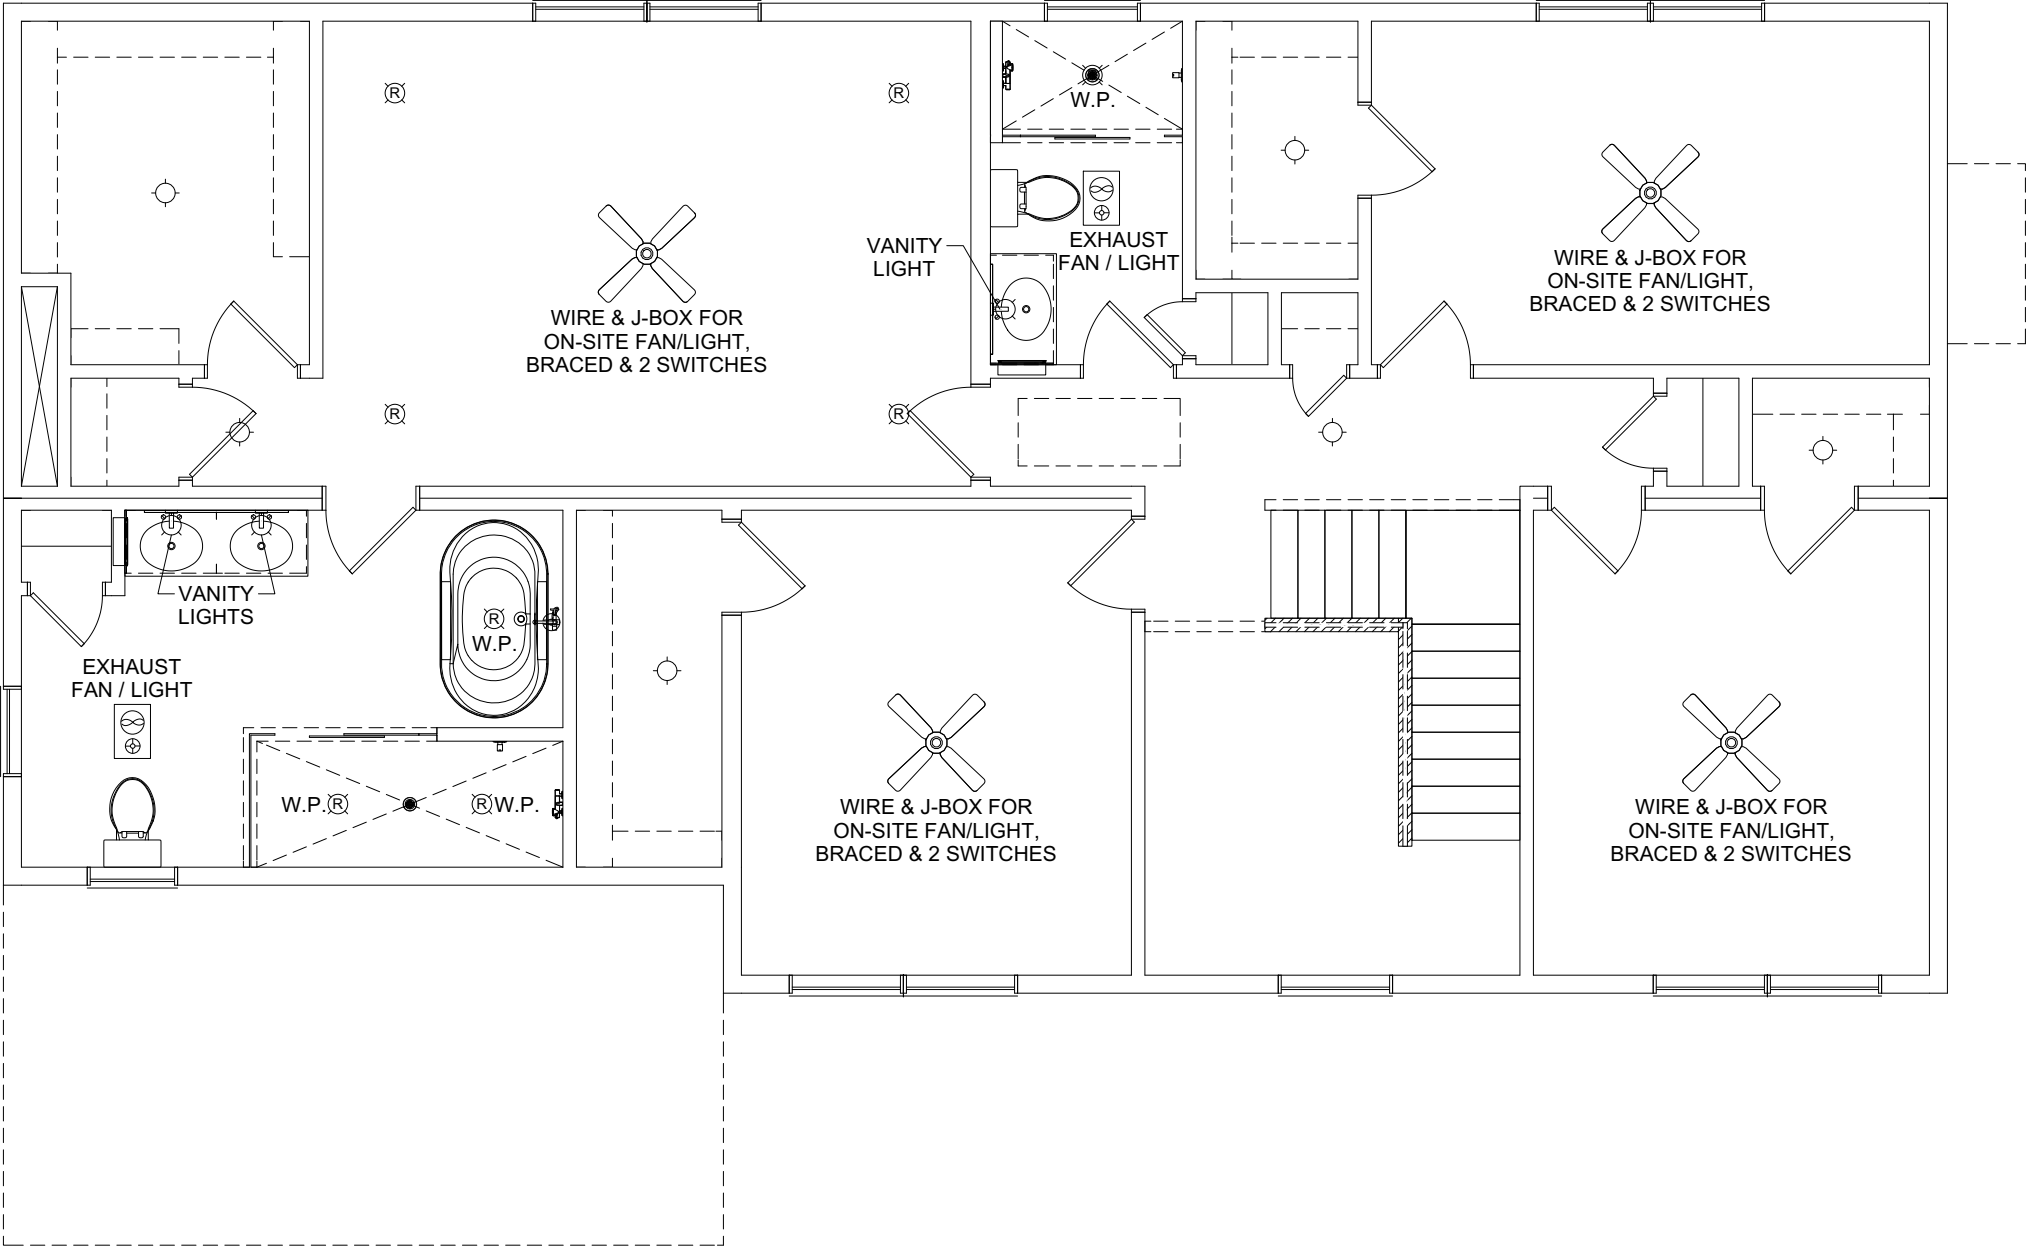

REVISION:	DATE:	BY:	REVISION:	DATE:	BY:
0	01/24/2024	SC	5	05/10/2024	SC
1	01/25/2024	SC			
2	03/10/2024	SC			
3	04/07/2024	SC			
4	04/27/2024	SC			

SECOND FLOOR ELECTRICAL PLAN

CUSTOMER:	
ADDRESS:	




impresa
MODULAR

1586 WINCHESTER AVE.
MARTINSBURG, WV 25405
FAX: 877-419-2505
WWW.IMPRESAMODULAR.COM

SCALE:
3/16"=1'-0"
SHEET:
1.4


DISCLAIMER: THESE DRAWINGS ARE ARTISTS RENDERINGS ONLY AND FINAL PROJECT MAY NOT BE IDENTICAL TO THAT SHOWN HERE. PROPRIETARY WORK PRODUCT AND PROPERTY OF EXPRESS HOMES, INC. DBA IMPRESA MODULAR AND DEVELOPED FOR THE EXCLUSIVE USE OF IMPRESA MODULAR. USE OF THESE DRAWINGS AND CONCEPTS CONTAINED THEREIN WITHOUT WRITTEN PERMISSION OF IMPRESA MODULAR IS PROHIBITED.

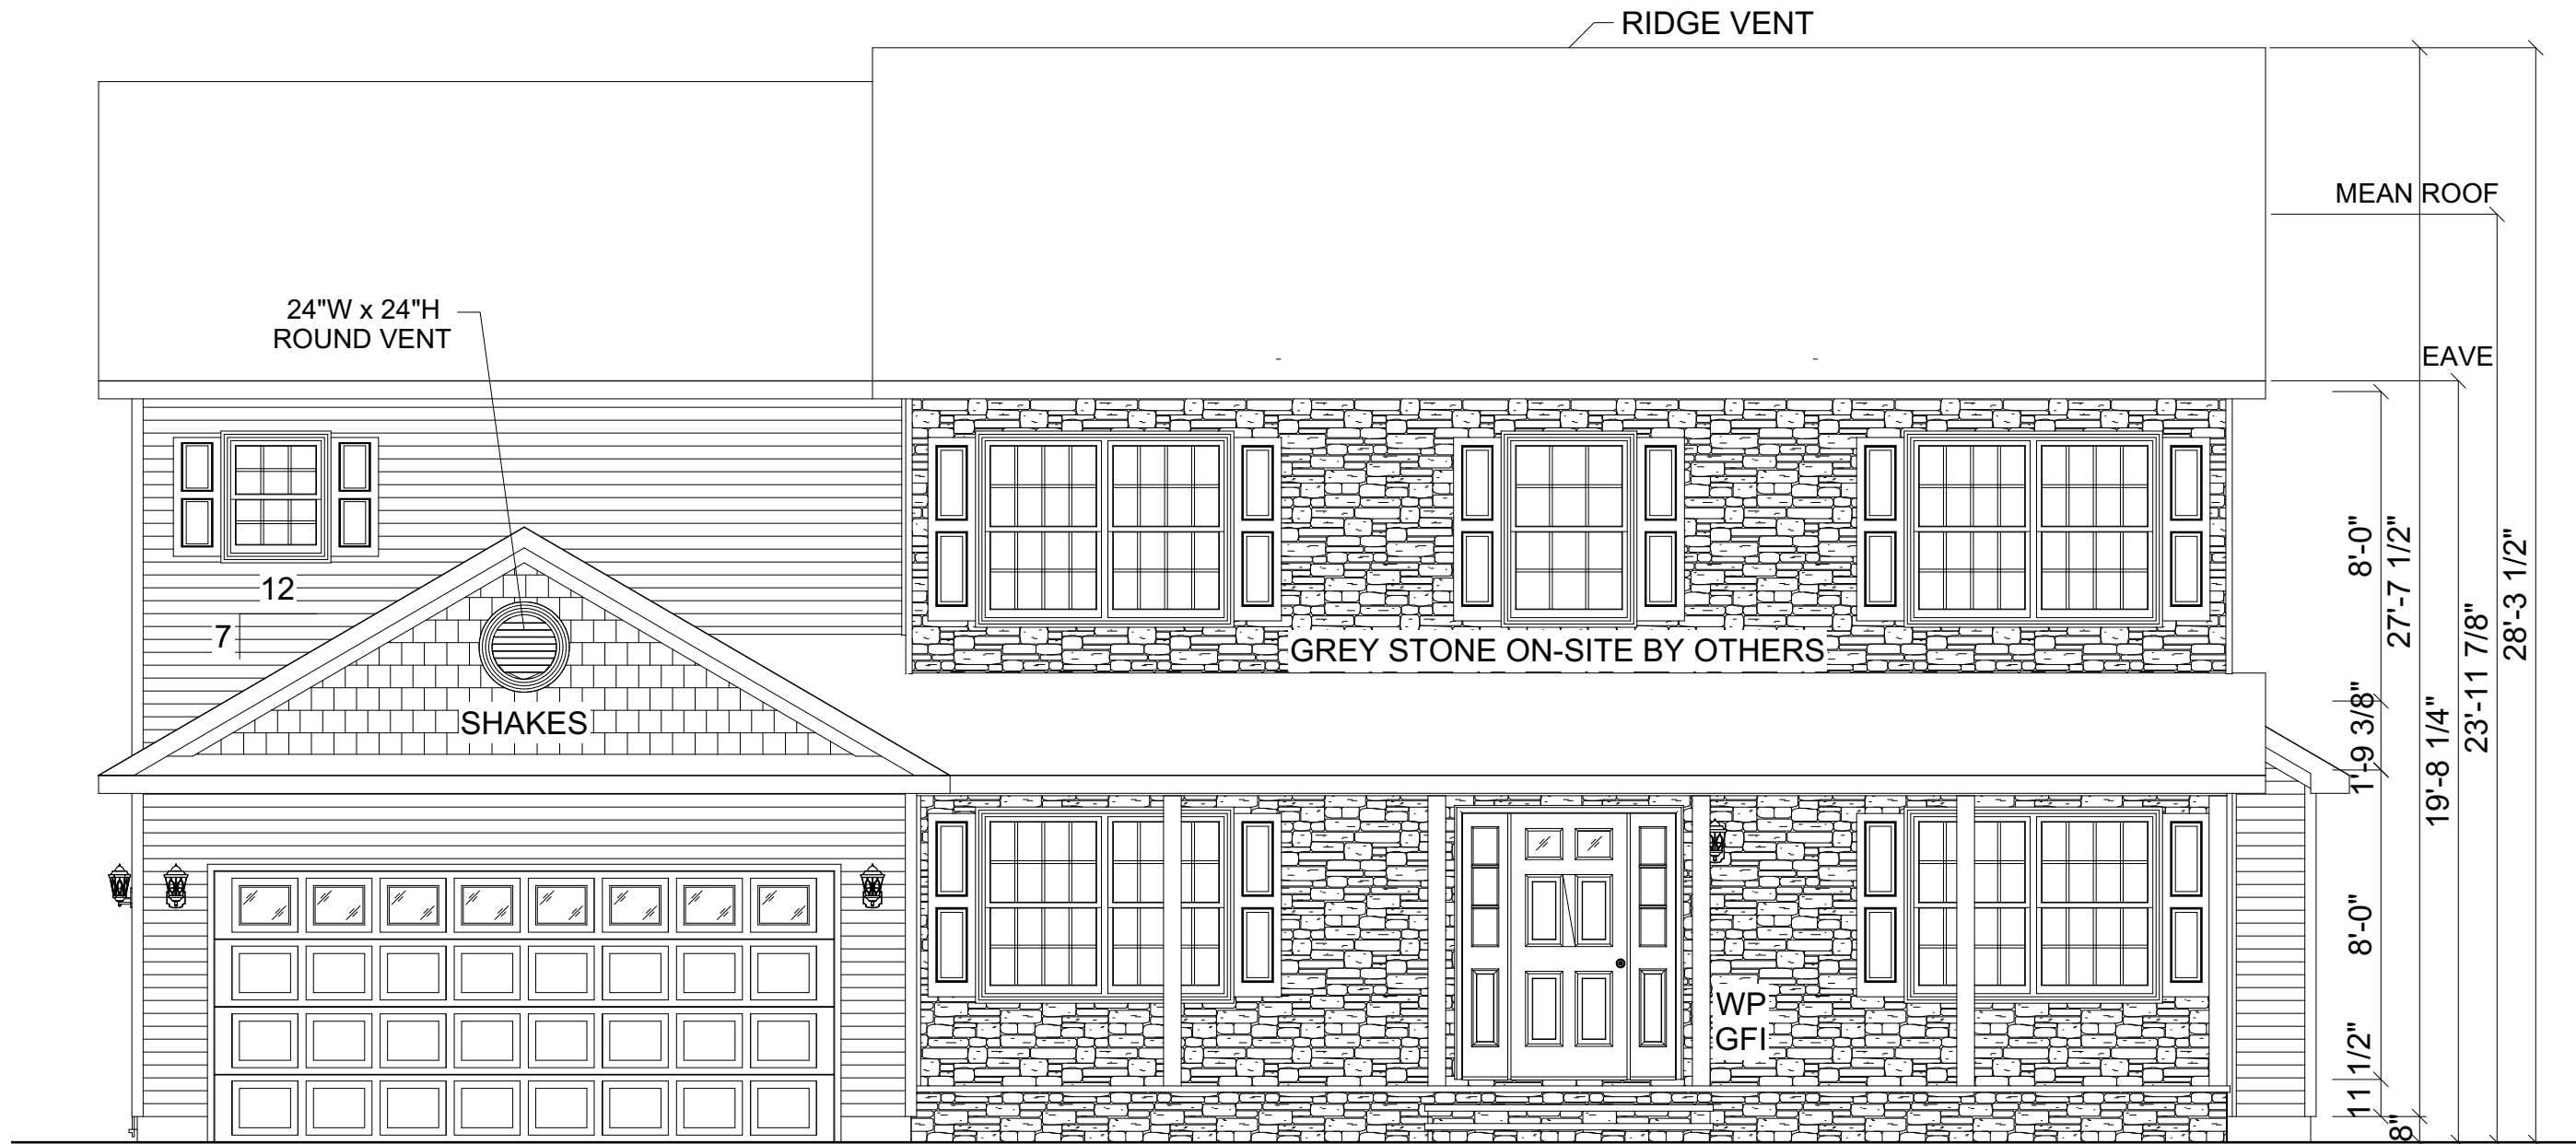

FRONT ELEVATION

REVISION:	DATE:	BY:	REVISION:	DATE:	BY:
0	01/24/2024	SC	5	05/10/2024	SC
1	01/25/2024	SC			
2	03/10/2024	SC			
3	04/07/2024	SC			
4	04/27/2024	SC			

ELEVATION	
CUSTOMER:	
ADDRESS:	

 **impresa**
MODULAR

1586 WINCHESTER AVE.
MARTINSBURG, WV 25405
FAX: 877-419-2505
WWW.IMPRESAMODULAR.COM

SCALE:
N.T.S.
SHEET:
2.0

DISCLAIMER: THESE DRAWINGS ARE ARTISTS RENDERINGS ONLY AND FINAL PROJECT MAY NOT BE IDENTICAL TO THAT SHOWN HERE. PROPRIETARY WORK PRODUCT AND PROPERTY OF EXPRESS HOMES, INC. DBA IMPRESA MODULAR AND DEVELOPED FOR THE EXCLUSIVE USE OF IMPRESA MODULAR. USE OF THESE DRAWINGS AND CONCEPTS CONTAINED THEREIN WITHOUT WRITTEN PERMISSION OF IMPRESA MODULAR IS PROHIBITED.



REAR ELEVATION

DISCLAIMER: THESE DRAWINGS ARE ARTISTS RENDERINGS ONLY AND FINAL PROJECT MAY NOT BE IDENTICAL TO THAT SHOWN HERE. PROPRIETARY WORK PRODUCT AND PROPERTY OF EXPRESS HOMES, INC. DBA IMPRESA MODULAR AND DEVELOPED FOR THE EXCLUSIVE USE OF IMPRESA MODULAR. USE OF THESE DRAWINGS AND CONCEPTS CONTAINED THEREIN WITHOUT WRITTEN PERMISSION OF IMPRESA MODULAR IS PROHIBITED.



impresa
MODULAR

1586 WINCHESTER AVE.
MARTINSBURG, WV 25405
FAX: 877-419-2505
WWW.IMPRESAMODULAR.COM

CUSTOMER:

ADDRESS:

ELEVATION

REVISION:	DATE:	BY:	REVISION:	DATE:	BY:
0	01/24/2024	SC	5	05/10/2024	SC
1	01/25/2024	SC			
2	03/10/2024	SC			
3	04/07/2024	SC			
4	04/27/2024	SC			

SCALE:
N.T.S.
SHEET:
2.1



LEFT ELEVATION

DISCLAIMER: THESE DRAWINGS ARE ARTISTS RENDERINGS ONLY AND FINAL PROJECT MAY NOT BE IDENTICAL TO THAT SHOWN HERE. PROPRIETARY WORK PRODUCT AND PROPERTY OF EXPRESS HOMES, INC. DBA IMPRESA MODULAR AND DEVELOPED FOR THE EXCLUSIVE USE OF IMPRESA MODULAR. USE OF THESE DRAWINGS AND CONCEPTS CONTAINED THEREIN WITHOUT WRITTEN PERMISSION OF IMPRESA MODULAR IS PROHIBITED.

CUSTOMER:		ELEVATION		REVISION:	DATE:	BY:	REVISION:	DATE:	BY:
				0	01/24/2024	SC	5	05/10/2024	SC
				1	01/25/2024	SC			
				2	03/10/2024	SC			
				3	04/07/2024	SC			
				4	04/27/2024	SC			
ADDRESS:									
SCALE:									
SHEET:									

**impresa**
MODULAR

1586 WINCHESTER AVE.
MARTINSBURG, WV 25405
FAX: 877-419-2505
WWW.IMPRESAMODULAR.COM

SCALE:
N.T.S.
SHEET:
2.2



RIGHT ELEVATION


DISCLAIMER: THESE DRAWINGS ARE ARTISTS RENDERINGS ONLY AND FINAL PROJECT MAY NOT BE IDENTICAL TO THAT SHOWN HERE. PROPRIETARY WORK PRODUCT AND PROPERTY OF EXPRESS HOMES, INC. DBA IMPRESA MODULAR AND DEVELOPED FOR THE EXCLUSIVE USE OF IMPRESA MODULAR. USE OF THESE DRAWINGS AND CONCEPTS CONTAINED THEREIN WITHOUT WRITTEN PERMISSION OF IMPRESA MODULAR IS PROHIBITED.

CUSTOMER:		ELEVATION		REVISION:	DATE:	BY:	REVISION:	DATE:	BY:
				0	01/24/2024	SC	5	05/10/2024	SC
ADDRESS:				1	01/25/2024	SC			
				2	03/10/2024	SC			
				3	04/07/2024	SC			
				4	04/27/2024	SC			



1586 WINCHESTER AVE.
MARTINSBURG, WV 25405
FAX: 877-419-2505
WWW.IMPRESAMODULAR.COM

SCALE:
N.T.S.
SHEET:
2.3

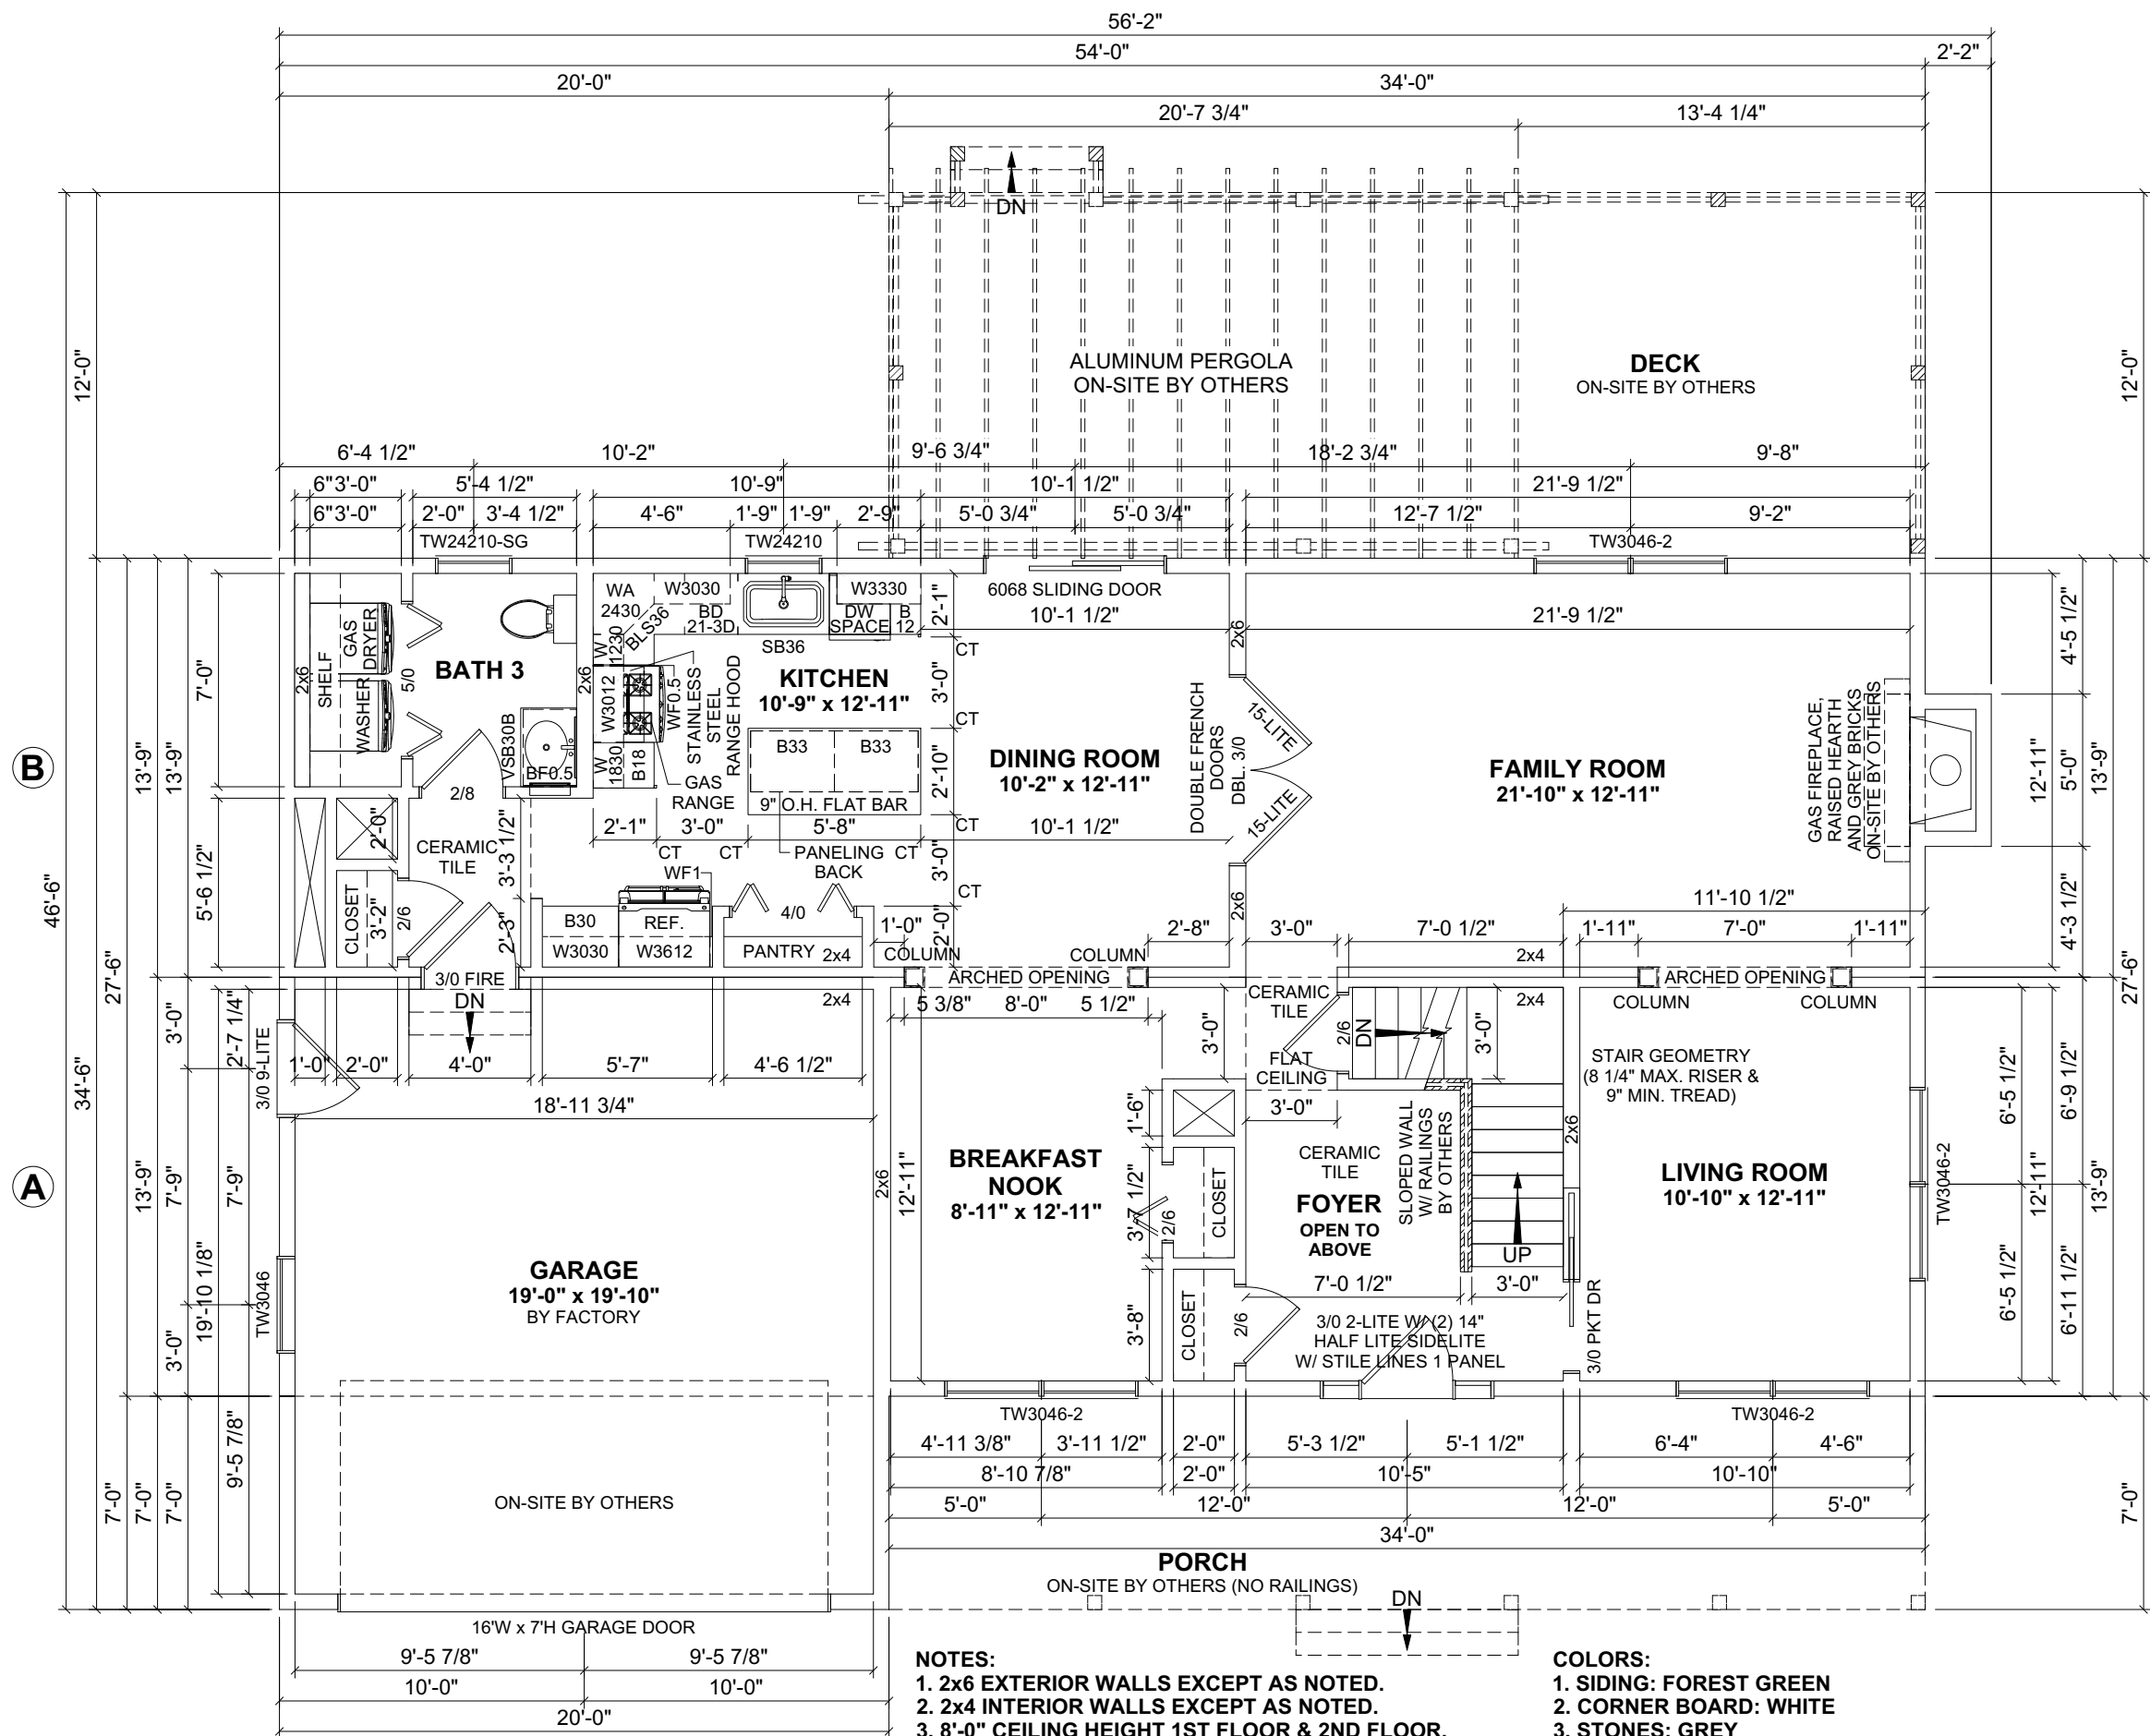

- NOTES:**
1. 2x6 EXTERIOR WALLS EXCEPT AS NOTED.
 2. 2x4 INTERIOR WALLS EXCEPT AS NOTED.
 3. 8'-0" CEILING HEIGHT 1ST FLOOR & 2ND FLOOR.
 4. 7/12 STORAGE ROOF EXCEPT AS NOTED.
 5. ANDERSEN 400 SERIES TILT-WASH WINDOWS.

- COLORS:**
1. SIDING: FOREST GREEN
 2. CORNER BOARD: WHITE
 3. STONES: GREY
 4. WINDOW EXTERIOR: ALUMINUM STAINED OAK
 5. WINDOW INTERIOR: WOOD

1ST FLOOR: 1,221 SQ.FT.
2ND FLOOR: 1,425 SQ.FT.
TOTAL AREA: 2,646 SQ.FT.

GARAGE: 415 SQ.FT.
PORCH: 238 SQ.FT.
DECK: 408 SQ.FT.
TOTAL AREA: 646 SQ.FT.

REVISION:	DATE:	BY:	REVISION:	DATE:	BY:
0	01/24/2024	SC	5	05/10/2024	SC
1	01/25/2024	SC			
2	03/10/2024	SC			
3	04/07/2024	SC			
4	04/27/2024	SC			

FIRST FLOOR PLAN

CUSTOMER: _____

ADDRESS: _____

impresa
MODULAR

1586 WINCHESTER AVE.
MARTINSBURG, WV 25405
FAX: 877-419-2505
WWW.IMPRESAMODULAR.COM


SCALE: _____

N.T.S.

SHEET: _____

3.0

DISCLAIMER: THESE DRAWINGS ARE ARTISTS RENDERINGS ONLY AND FINAL PROJECT MAY NOT BE IDENTICAL TO THAT SHOWN HERE. PROPRIETARY WORK PRODUCT AND PROPERTY OF EXPRESS HOMES, INC. DBA IMPRESA MODULAR AND DEVELOPED FOR THE EXCLUSIVE USE OF IMPRESA MODULAR. USE OF THESE DRAWINGS AND CONCEPTS CONTAINED THEREIN WITHOUT WRITTEN PERMISSION OF IMPRESA MODULAR IS PROHIBITED.

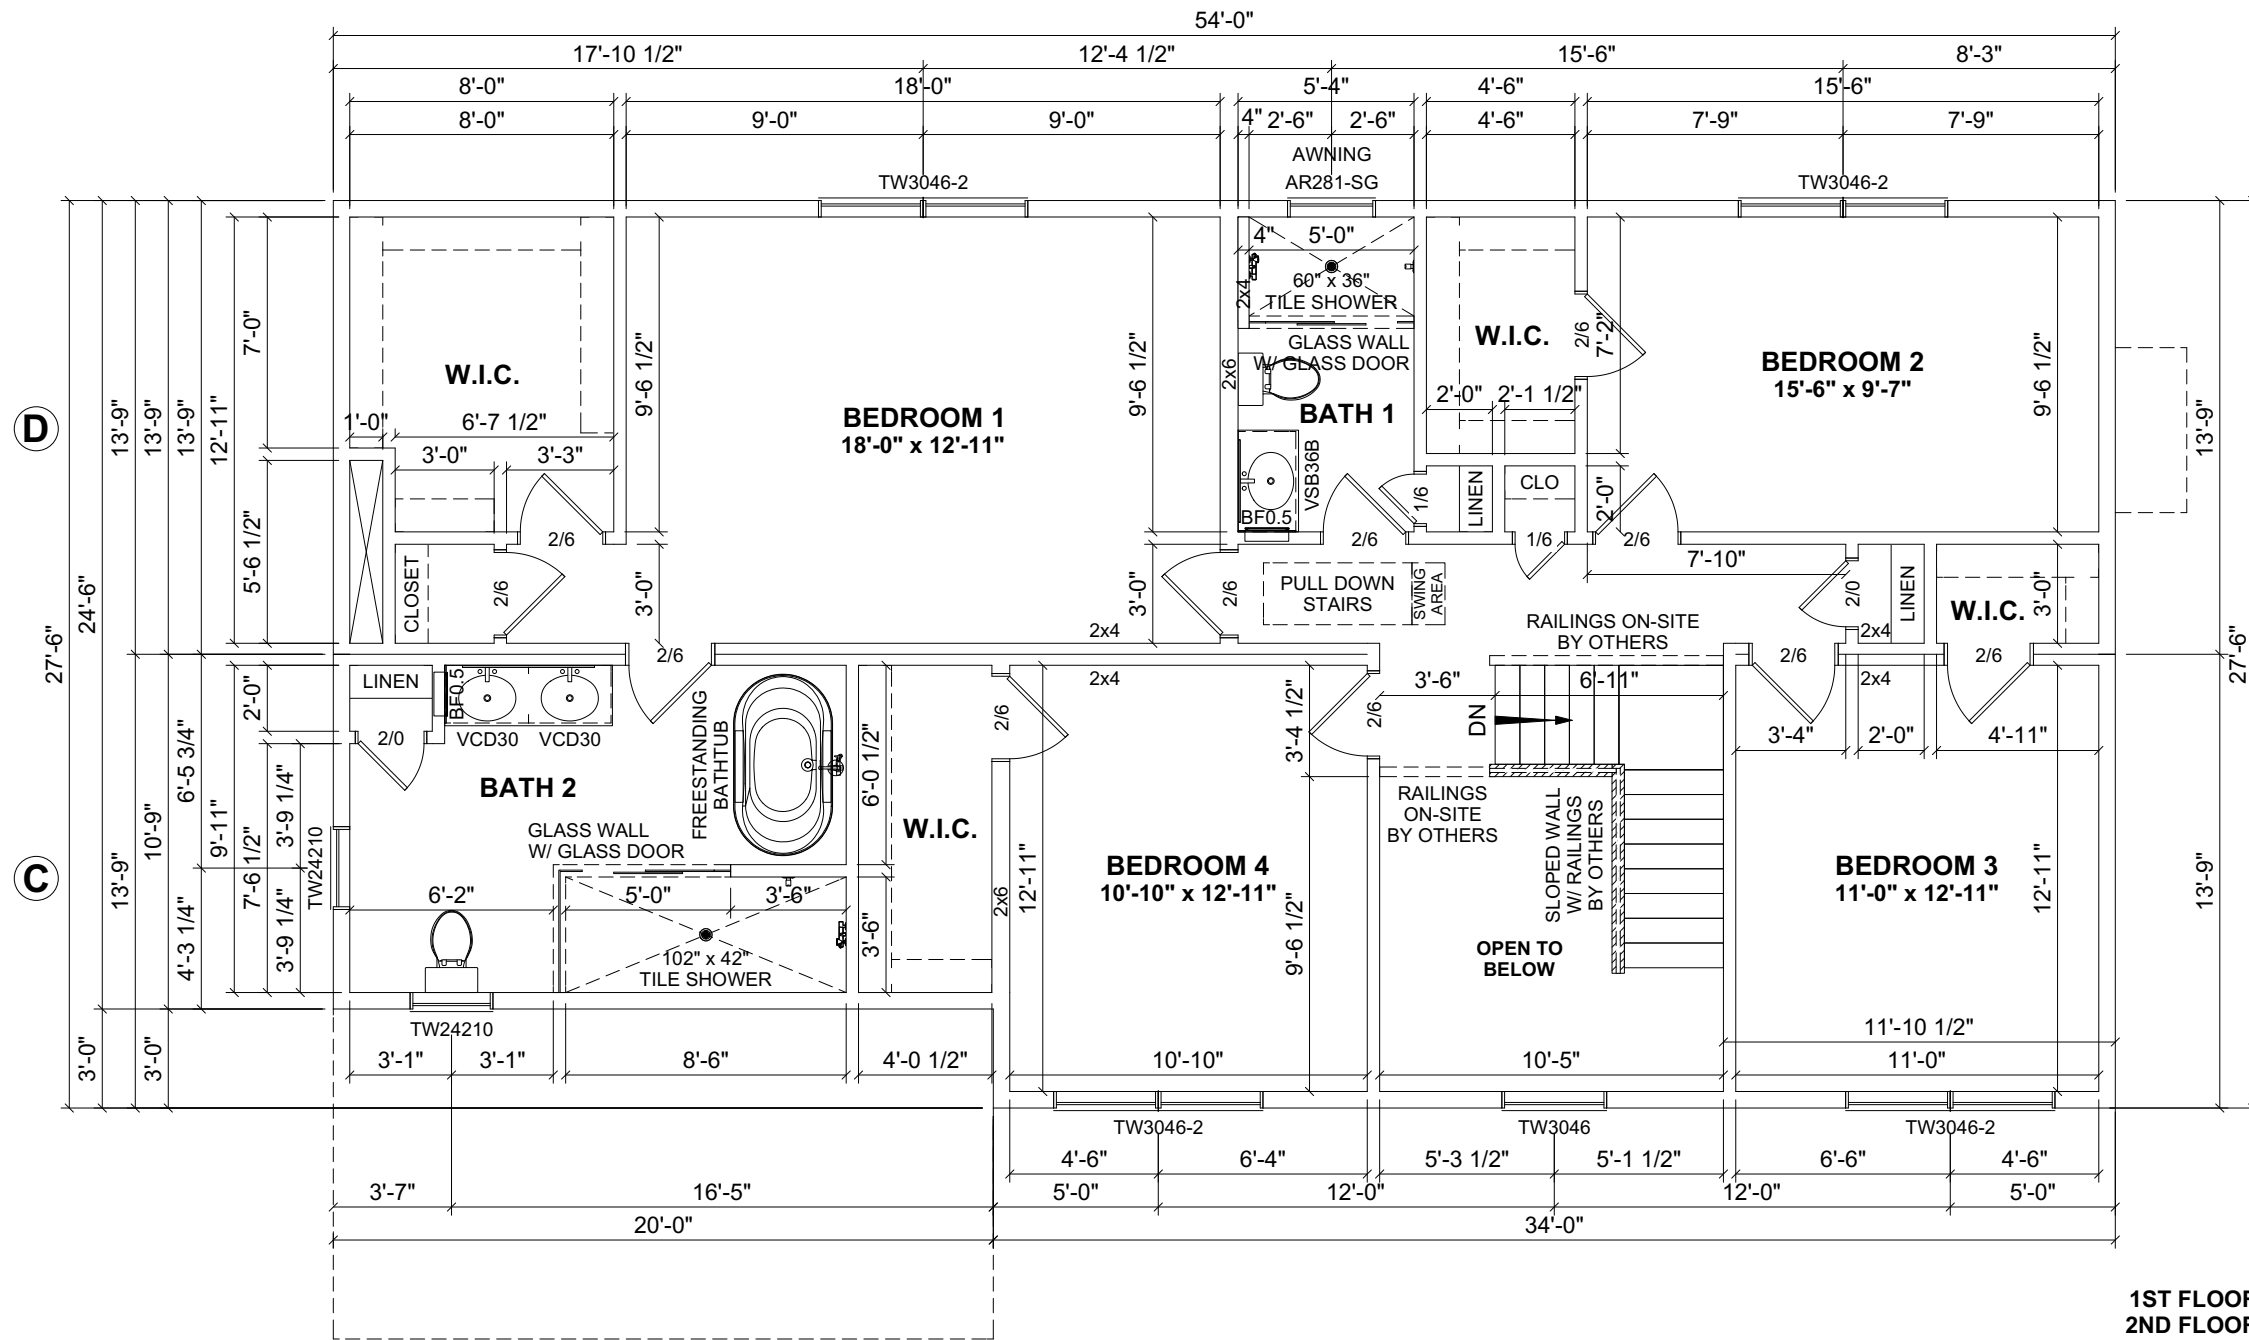

1ST FLOOR: 1,221 SQ.FT.
2ND FLOOR: 1,425 SQ.FT.
TOTAL AREA: 2,646 SQ.FT.

GARAGE: 415 SQ.FT.

PORCH: 238 SQ.FT.
DECK: 408 SQ.FT.
TOTAL AREA: 646 SQ.FT.

SECOND FLOOR PLAN

CUSTOMER:

ADDRESS:



SCALE:

N.T.S.

SHEET:

3.1

REVISION:	DATE:	BY:	REVISION:	DATE:	BY:
0	01/24/2024	SC	5	05/10/2024	SC
1	01/25/2024	SC			
2	03/10/2024	SC			
3	04/07/2024	SC			
4	04/27/2024	SC			

DISCLAIMER: THESE DRAWINGS ARE ARTISTS RENDERINGS ONLY AND FINAL PROJECT MAY NOT BE IDENTICAL TO THAT SHOWN HERE. PROPRIETARY WORK PRODUCT AND PROPERTY OF EXPRESS HOMES, INC. DBA IMPRESA MODULAR AND DEVELOPED FOR THE EXCLUSIVE USE OF IMPRESA MODULAR. USE OF THESE DRAWINGS AND CONCEPTS CONTAINED THEREIN WITHOUT WRITTEN PERMISSION OF IMPRESA MODULAR IS PROHIBITED.