

- NOTES:**
1. 2x6 EXTERIOR WALLS EXCEPT AS NOTED.
  2. 2x4 INTERIOR WALLS EXCEPT AS NOTED.
  3. 8'-8" CEILING HEIGHT.
  4. 7/12 NON-STORAGE ROOF EXCEPT AS NOTED.

- NOTE:**
- 1: ALL WINDOWS TO BE MARVIN SIGNATURE COLLECTION MODERN - ALUMINUM INTERIOR, FIBERGLASS EXTERIOR. COLOR = EBONY, NARROW FRAME, SQUARE SURFACE DUAL PANE, MATTE BLACK MODERN HARDWARE
  - 2: PICTURE, TRAP AND TRIANGLE WINDOWS ARE FIXED.
  - 3: INCLUDE MARVIN BRIGHT VIEW SCREENS.
  - 4: THE MARVIN ULTIMATE SLIDING DOORS WOOD INTERIOR ALUMINUM EXTERIOR, SLIDING SCREEN DOOR, SAME AS THE BLACK HARDWARE.

**FLOOR AREA: 2,383 SQ.FT.**

DECK 1: 450 SQ.FT.  
 DECK 2: 330 SQ.FT.  
 TOTAL AREA: 780 SQ.FT.

REVISION:	DATE:	BY:	REVISION:	DATE:	BY:
0	05/09/2023	SC	6	11/14/2023	SC
1	07/20/2023	SC	7	12/31/2023	SC
2	07/21/2023	SC	8	01/06/2024	SC
3	09/15/2023	SC	9	02/23/2024	SC
4	09/19/2023	SC	10	03/02/2024	SC
5	09/28/2023	SC	11	03/06/2024	SC

# FLOOR PLAN

CUSTOMER:

ADDRESS:

**impresa**  
MODULAR

1586 WINCHESTER AVE.  
 MARTINSBURG, WV 25405  
 FAX: 877-419-2505  
 WWW.IMPRESAMODULAR.COM

SCALE:


N.T.S.

SHEET:

1.1

**DISCLAIMER:** THESE DRAWINGS ARE ARTISTS RENDERINGS ONLY AND FINAL PROJECT MAY NOT BE IDENTICAL TO THAT SHOWN HERE. PROPRIETARY WORK PRODUCT AND PROPERTY OF EXPRESS HOMES, INC. DBA IMPRESA MODULAR AND DEVELOPED FOR THE EXCLUSIVE USE OF IMPRESA MODULAR. USE OF THESE DRAWINGS AND CONCEPTS CONTAINED THEREIN WITHOUT WRITTEN PERMISSION OF IMPRESA MODULAR IS PROHIBITED.

ELECTRICAL LEGEND	
	ELECTRIC PANEL
	METER
	LIGHT SWITCH
	3 WAY LIGHT SWITCH
	4 WAY LIGHT SWITCH
	SINGLE DIMMER LIGHT SWITCH
	3 WAY DIMMER LIGHT SWITCH
	110V DUPLEX RECEPTACLE
	110V DUPLEX SPLIT RECEPTACLE
	EXTERIOR WP GFI OUTLET
	220V DUPLEX RECEPTACLE
	CEILING MOUNTED OUTLET
	FLOOR OUTLET
	QUADRUPLIX RECEPTACLE
	STANDARD CEILING LIGHT
	PENDANT LIGHT
	RECESSED LIGHT
	UNDER CABINET LIGHT
	CHANDELIER LIGHT
	VANITY WALL MOUNT LIGHT
	WALL SCONCE
	EXTERIOR WALL LIGHT
	SPOT LIGHT
	MOTION LIGHT
	FLUORESCENT
	JUNCTION BOX
	EXHAUST FAN
	EXHAUST FAN / LIGHT
	EXHAUST FAN, LIGHT & HEAT
	CEILING FAN OR FAN/LIGHT -SEE PLAN FOR INFO
	SMOKE DETECTOR
	CO/SMOKE DETECTOR
	TV
	PHONE
	HUMIDISTAT
	THERMOSTAT
	ETHERNET
	CABLE
	DOOR CHIME
	DOORBELL
	EMERGENCY LIGHTING
	EXIT SIGN

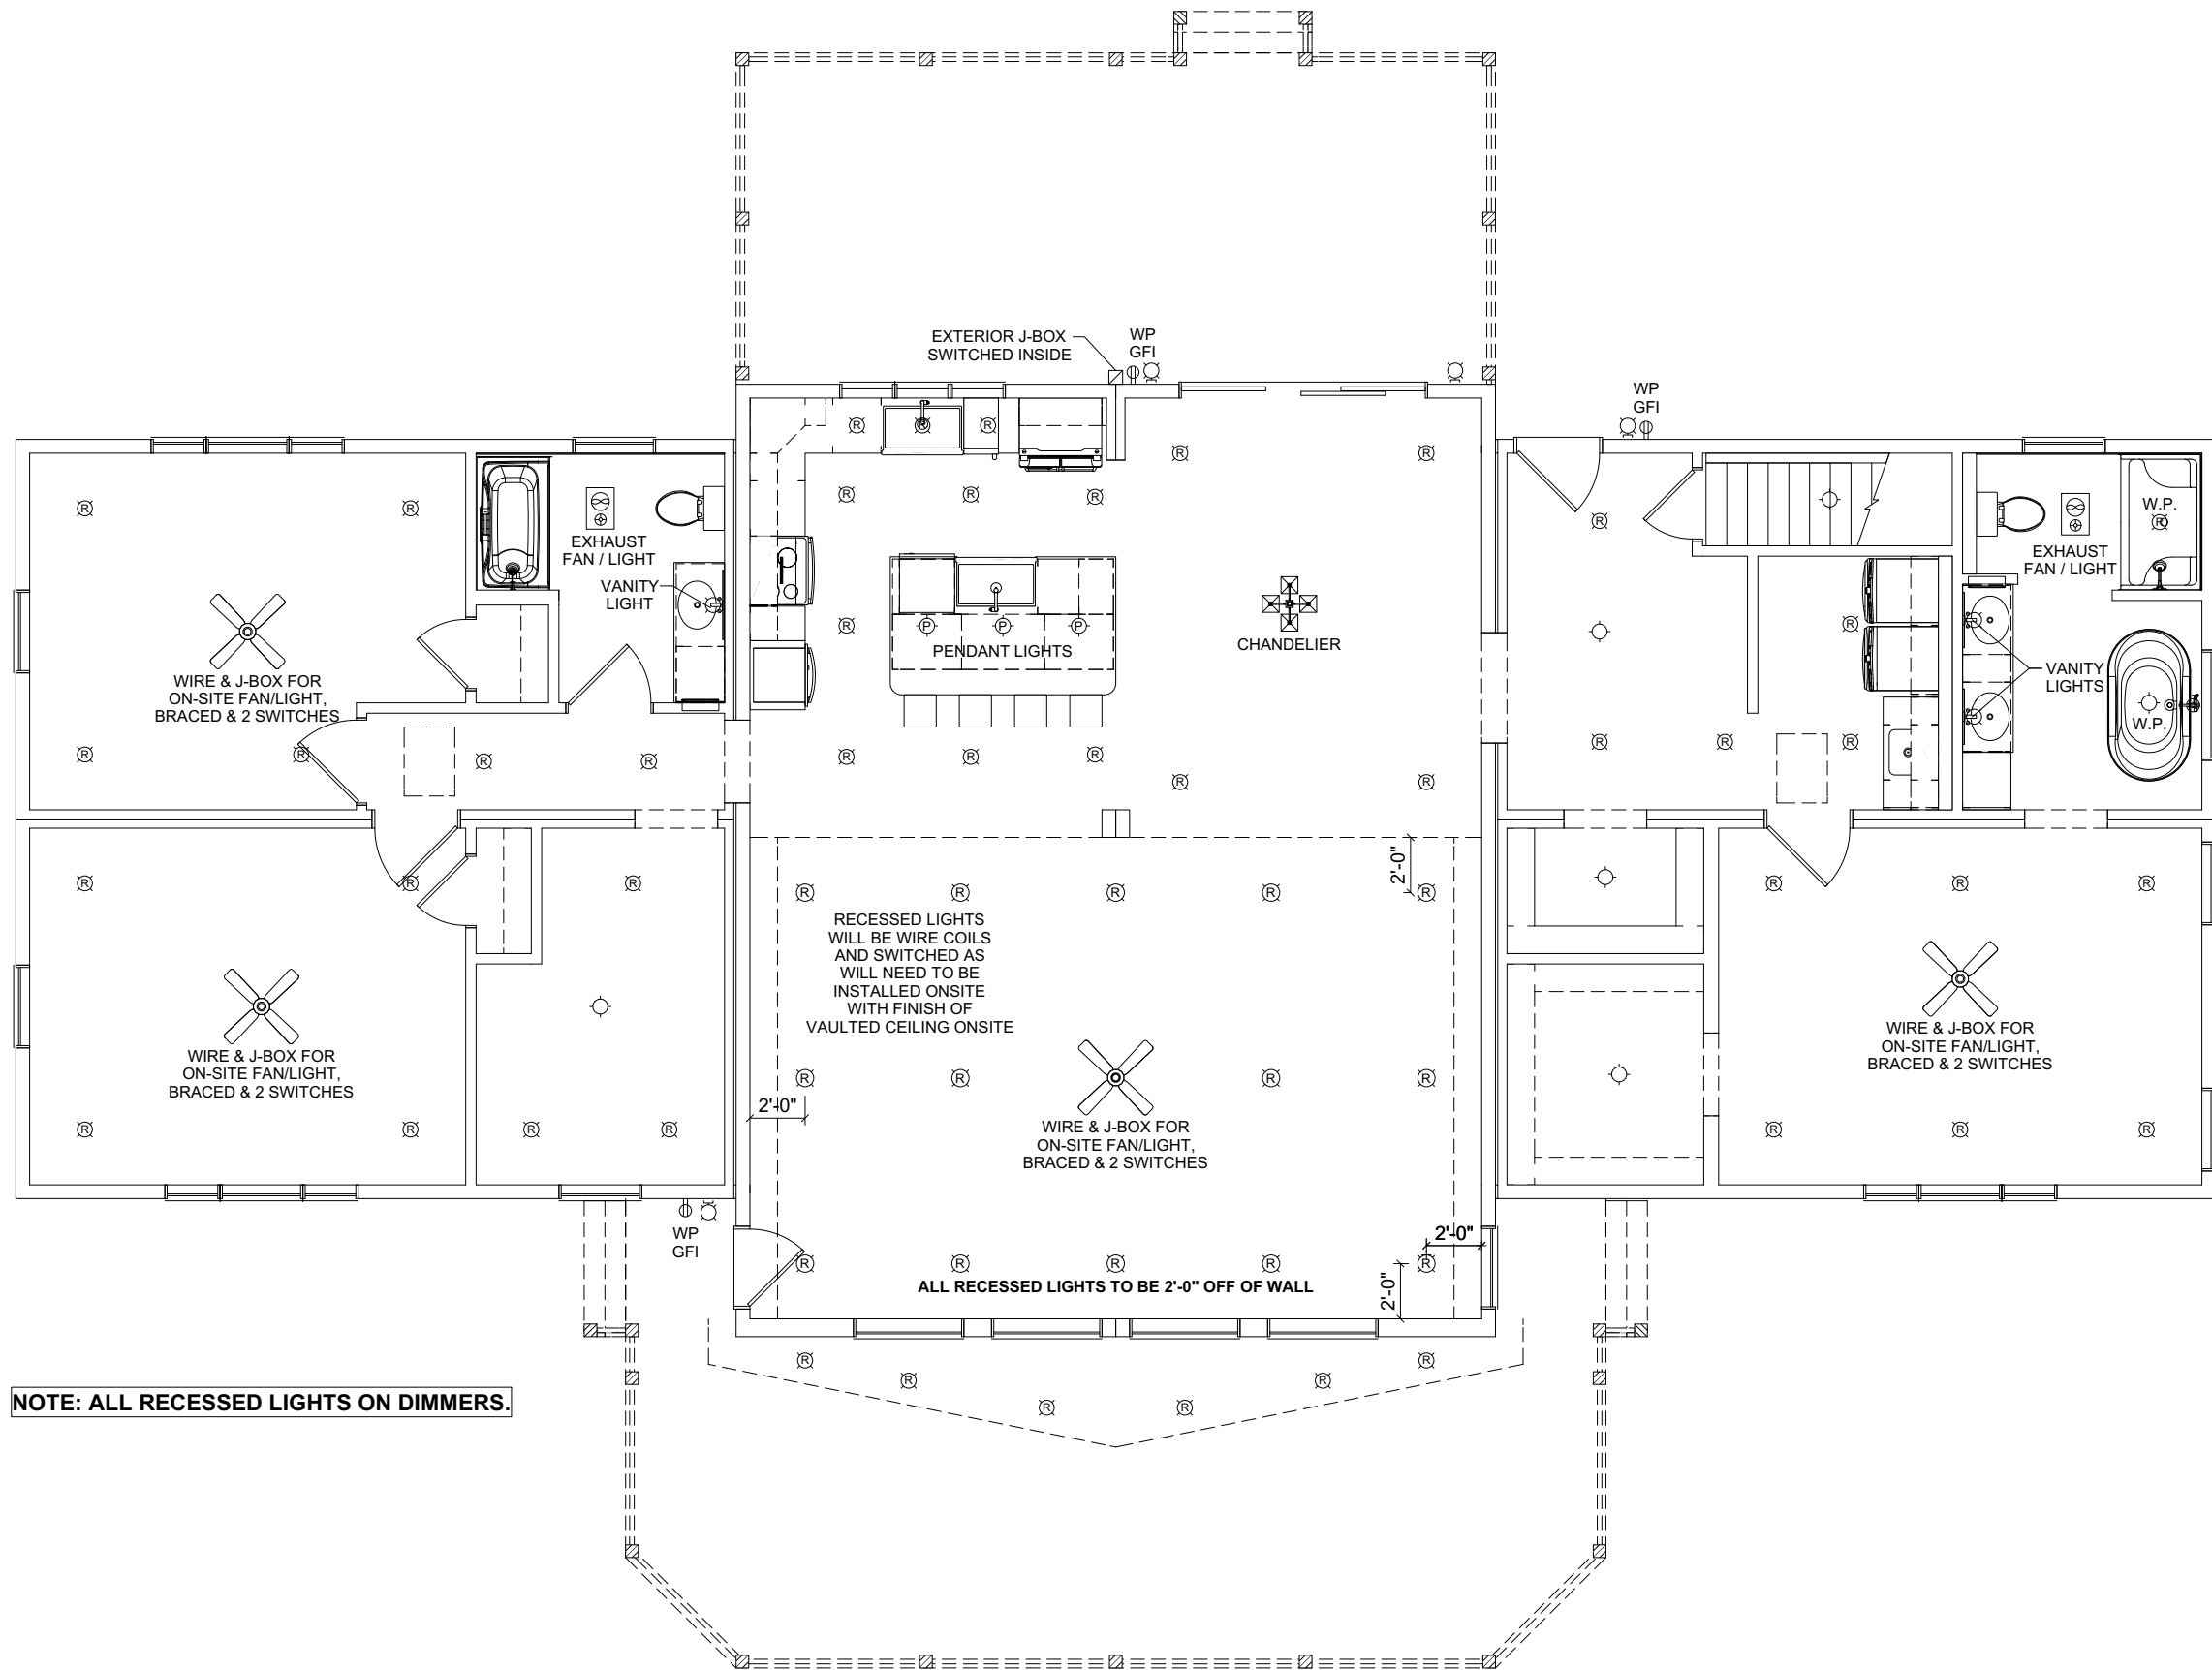

**NOTE: ALL RECESSED LIGHTS ON DIMMERS.**

REVISION:	DATE:	BY:	REVISION:	DATE:	BY:
0	05/09/2023	SC	6	11/14/2023	SC
1	07/20/2023	SC	7	12/31/2023	SC
2	07/21/2023	SC	8	01/06/2024	SC
3	09/15/2023	SC	9	02/23/2024	SC
4	09/19/2023	SC	10	03/02/2024	SC
5	09/28/2023	SC	11	03/06/2024	SC

**ELECTRICAL PLAN**

CUSTOMER:

ADDRESS:


**impresa**  
MODULAR  
1586 WINCHESTER AVE.  
MARTINSBURG, WV 25405  
FAX: 877-419-2505  
WWW.IMPRESAMODULAR.COM

SCALE:  
3/16"=1'-0"


SHEET:

**1.3**

**DISCLAIMER:** THESE DRAWINGS ARE ARTISTS RENDERINGS ONLY AND FINAL PROJECT MAY NOT BE IDENTICAL TO THAT SHOWN HERE. PROPRIETARY WORK PRODUCT AND PROPERTY OF EXPRESS HOMES, INC. DBA IMPRESA MODULAR AND DEVELOPED FOR THE EXCLUSIVE USE OF IMPRESA MODULAR. USE OF THESE DRAWINGS AND CONCEPTS CONTAINED THEREIN WITHOUT WRITTEN PERMISSION OF IMPRESA MODULAR IS PROHIBITED.

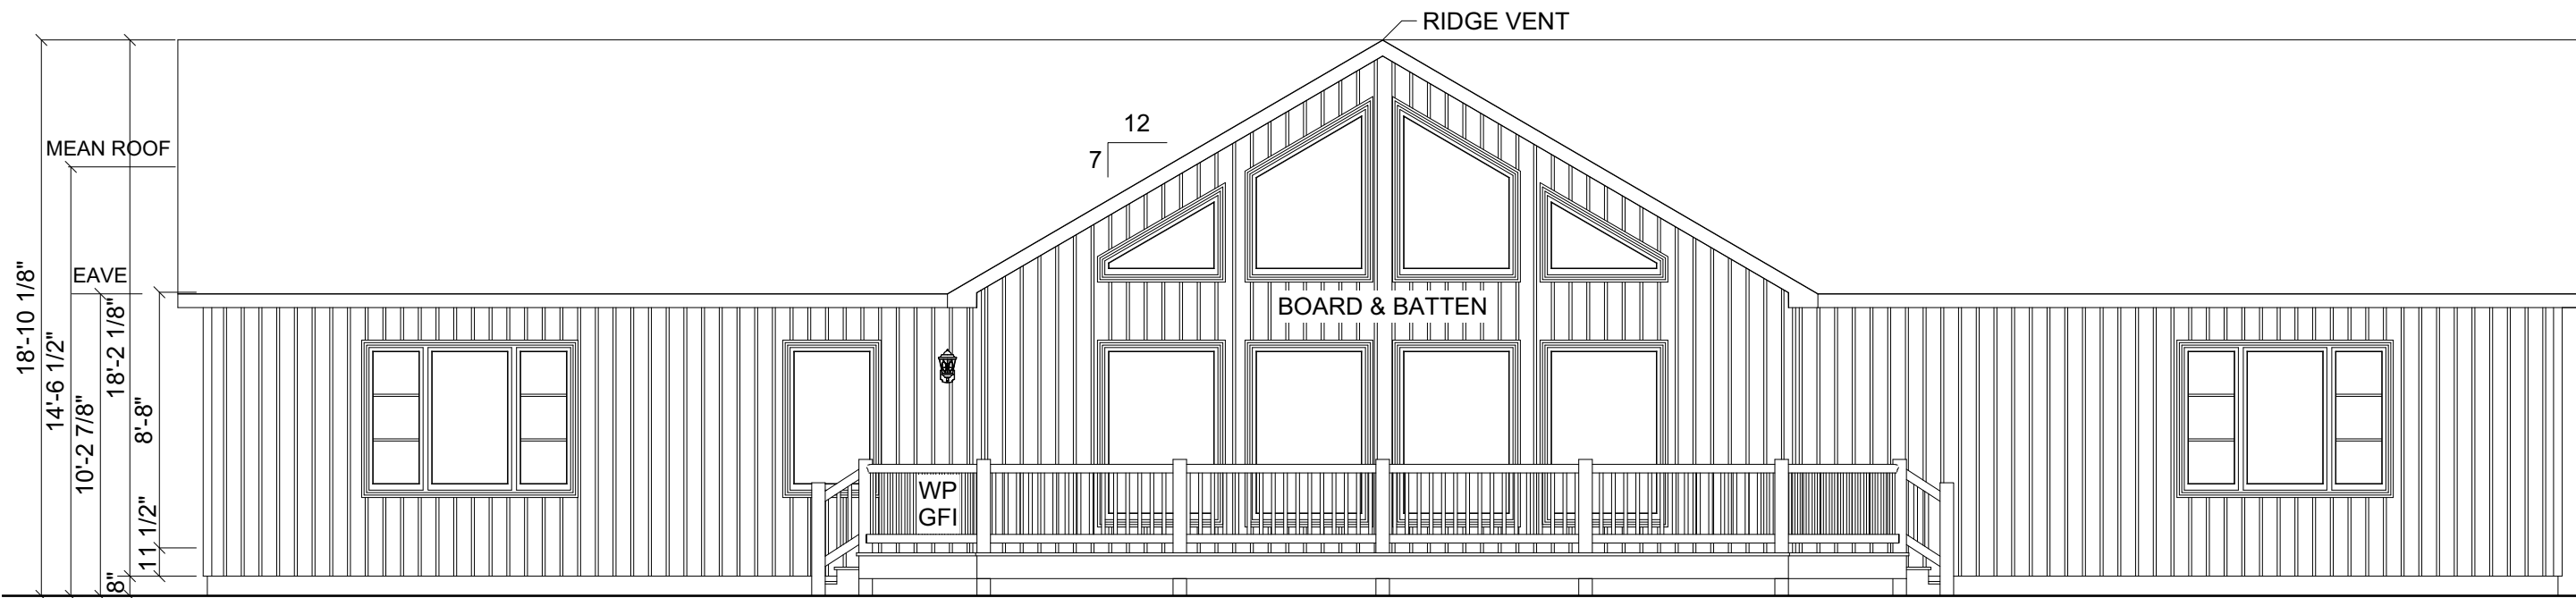

**FRONT ELEVATION**

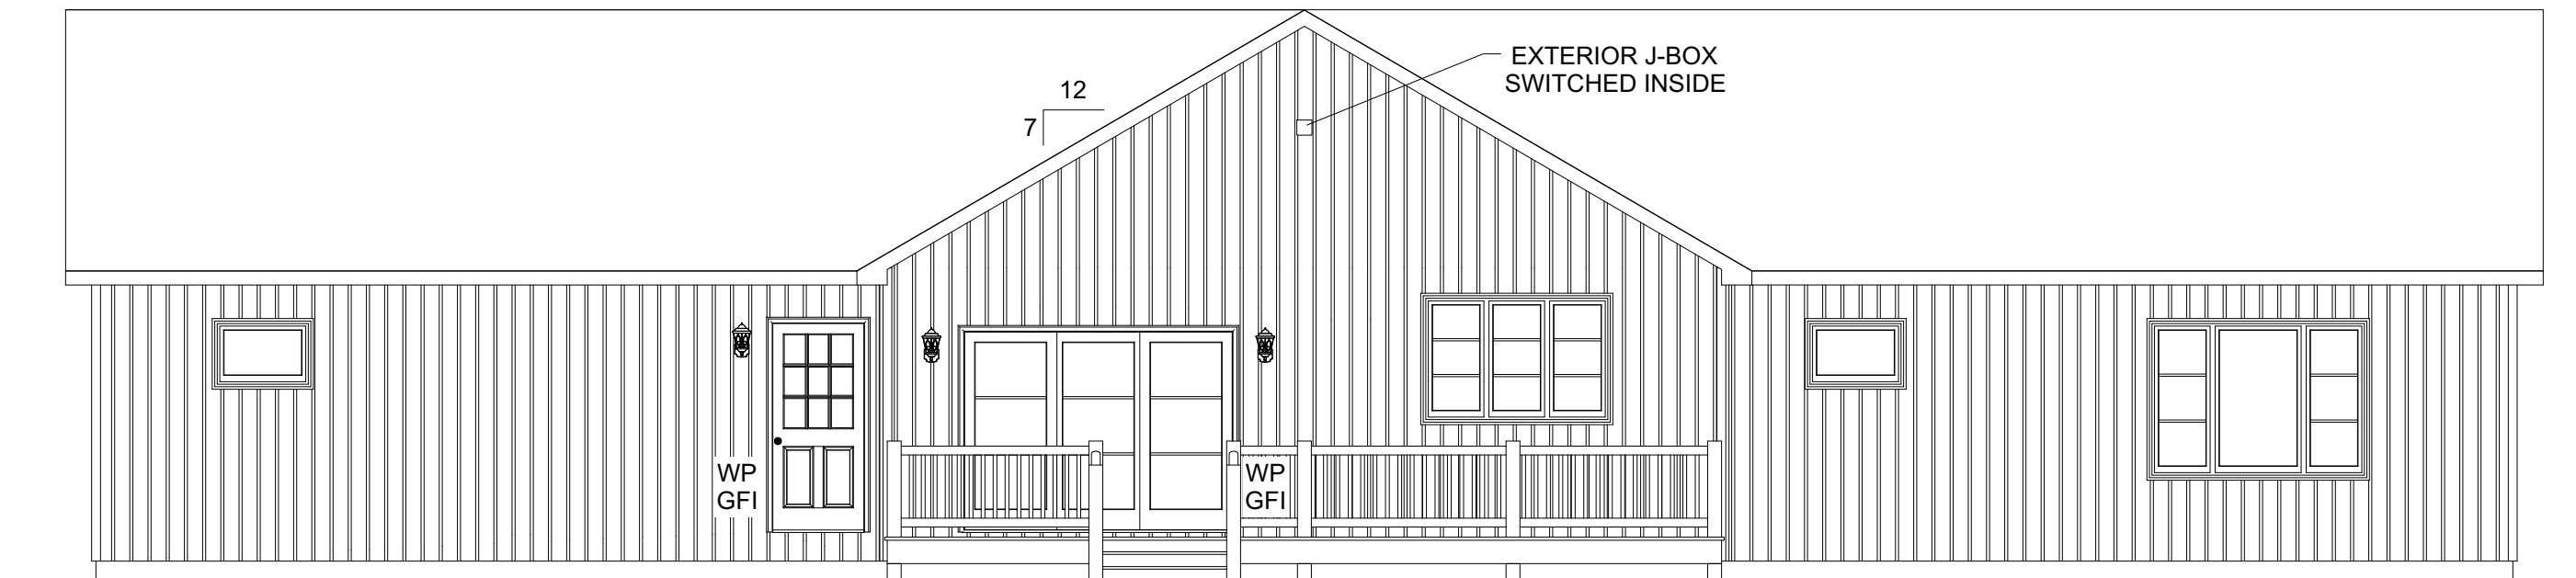

**REAR ELEVATION**

REVISION:	DATE:	BY:	REVISION:	DATE:	BY:
0	05/09/2023	SC	6	11/14/2023	SC
1	07/20/2023	SC	7	12/31/2023	SC
2	07/21/2023	SC	8	01/06/2024	SC
3	09/15/2023	SC	9	02/23/2024	SC
4	09/19/2023	SC	10	03/02/2024	SC
5	09/28/2023	SC	11	03/06/2024	SC

**ELEVATIONS**

CUSTOMER:

ADDRESS:

**impresa**  
MODULAR

1566 WINCHESTER AVE.  
MARTINSBURG, WV 25405  
FAX: 877-419-2505  
WWW.IMPRESAMODULAR.COM


SCALE:

N.T.S.


SHEET:

**2.0**

**DISCLAIMER:** THESE DRAWINGS ARE ARTISTS RENDERINGS ONLY AND FINAL PROJECT MAY NOT BE IDENTICAL TO THAT SHOWN HERE. PROPRIETARY WORK PRODUCT AND PROPERTY OF EXPRESS HOMES, INC. DBA IMPRESA MODULAR AND DEVELOPED FOR THE EXCLUSIVE USE OF IMPRESA MODULAR. USE OF THESE DRAWINGS AND CONCEPTS CONTAINED THEREIN WITHOUT WRITTEN PERMISSION OF IMPRESA MODULAR IS PROHIBITED.

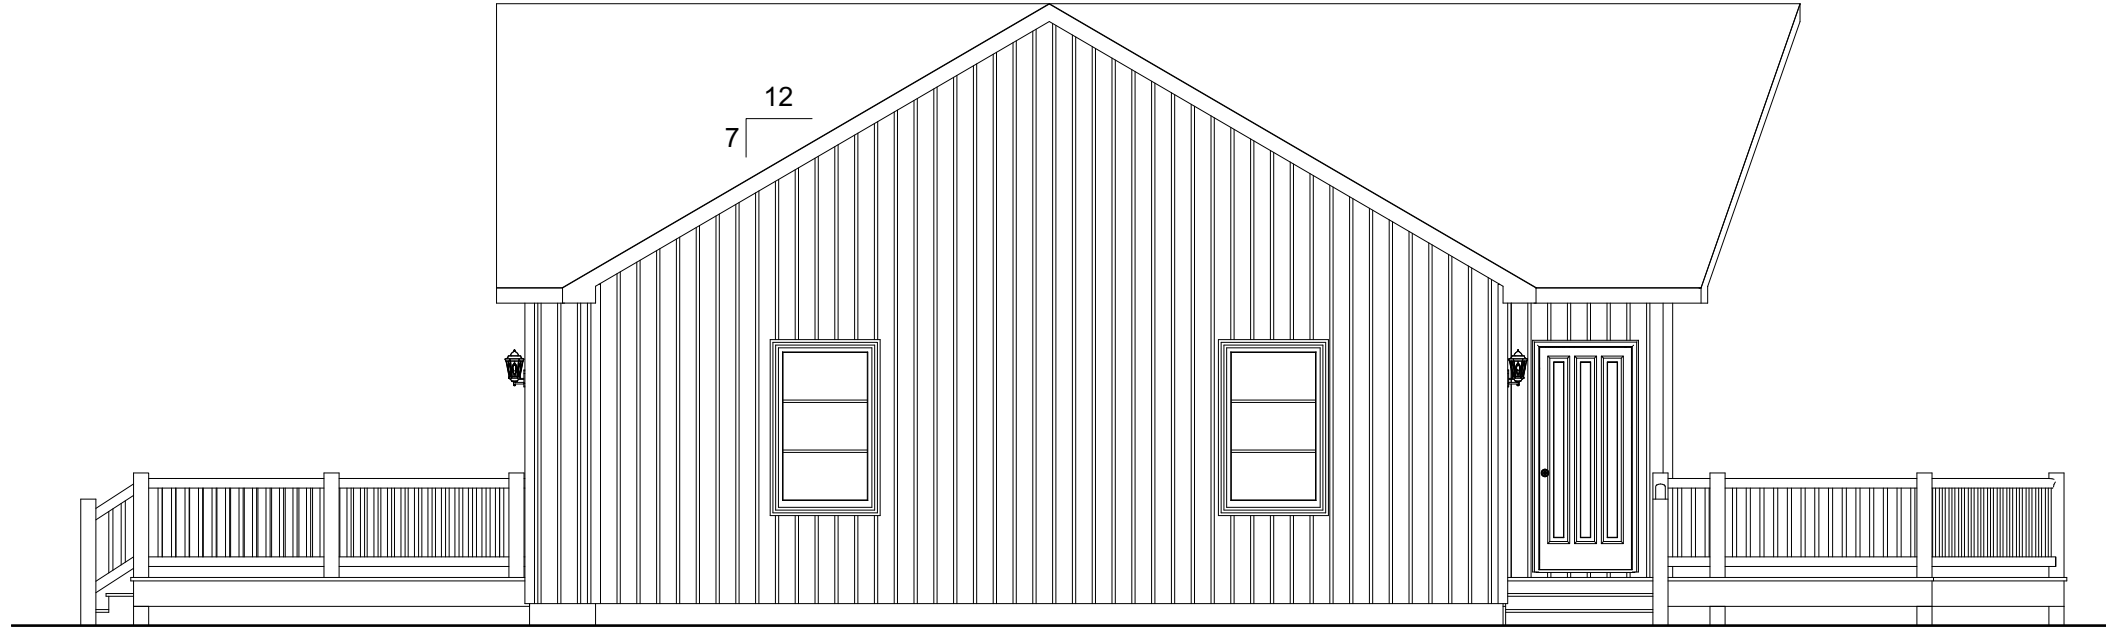

**LEFT ELEVATION**

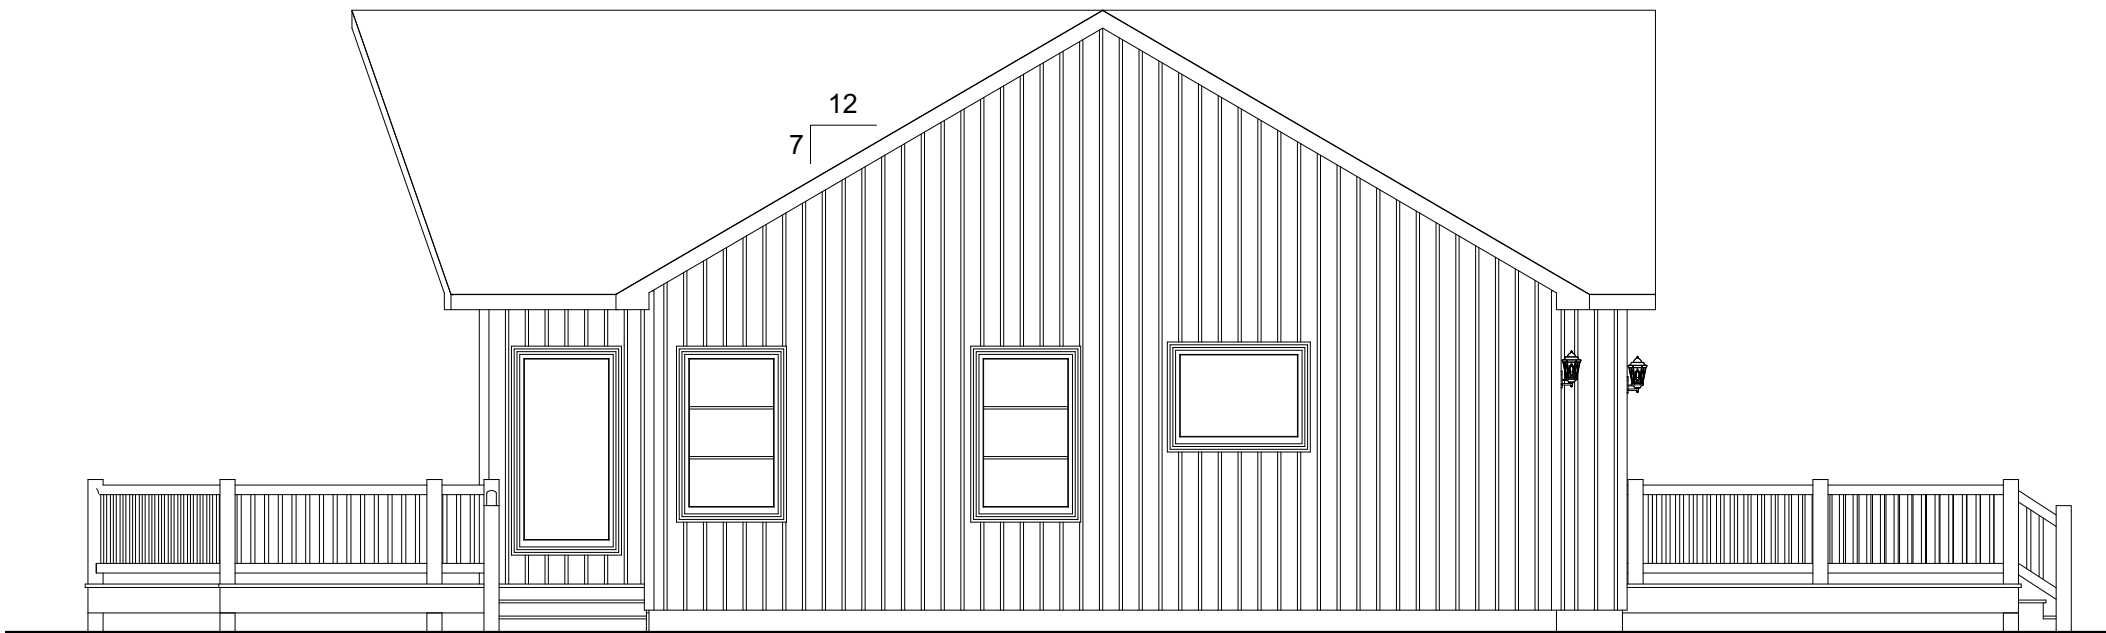

**RIGHT ELEVATION**

REVISION:	DATE:	BY:	REVISION:	DATE:	BY:
0	05/09/2023	SC	6	11/14/2023	SC
1	07/20/2023	SC	7	12/31/2023	SC
2	07/21/2023	SC	8	01/06/2024	SC
3	09/15/2023	SC	9	02/23/2024	SC
4	09/19/2023	SC	10	03/02/2024	SC
5	09/28/2023	SC	11	03/06/2024	SC

**ELEVATIONS**

CUSTOMER:

ADDRESS:



1586 WINCHESTER AVE.  
MARTINSBURG, WV 25405  
FAX: 877-419-2505  
WWW.IMPRESAMODULAR.COM


SCALE:

N.T.S.

SHEET:

**2.1**

**DISCLAIMER:** THESE DRAWINGS ARE ARTISTS RENDERINGS ONLY AND FINAL PROJECT MAY NOT BE IDENTICAL TO THAT SHOWN HERE. PROPRIETARY WORK PRODUCT AND PROPERTY OF EXPRESS HOMES, INC. DBA IMPRESA MODULAR AND DEVELOPED FOR THE EXCLUSIVE USE OF IMPRESA MODULAR. USE OF THESE DRAWINGS AND CONCEPTS CONTAINED THEREIN WITHOUT WRITTEN PERMISSION OF IMPRESA MODULAR IS PROHIBITED.

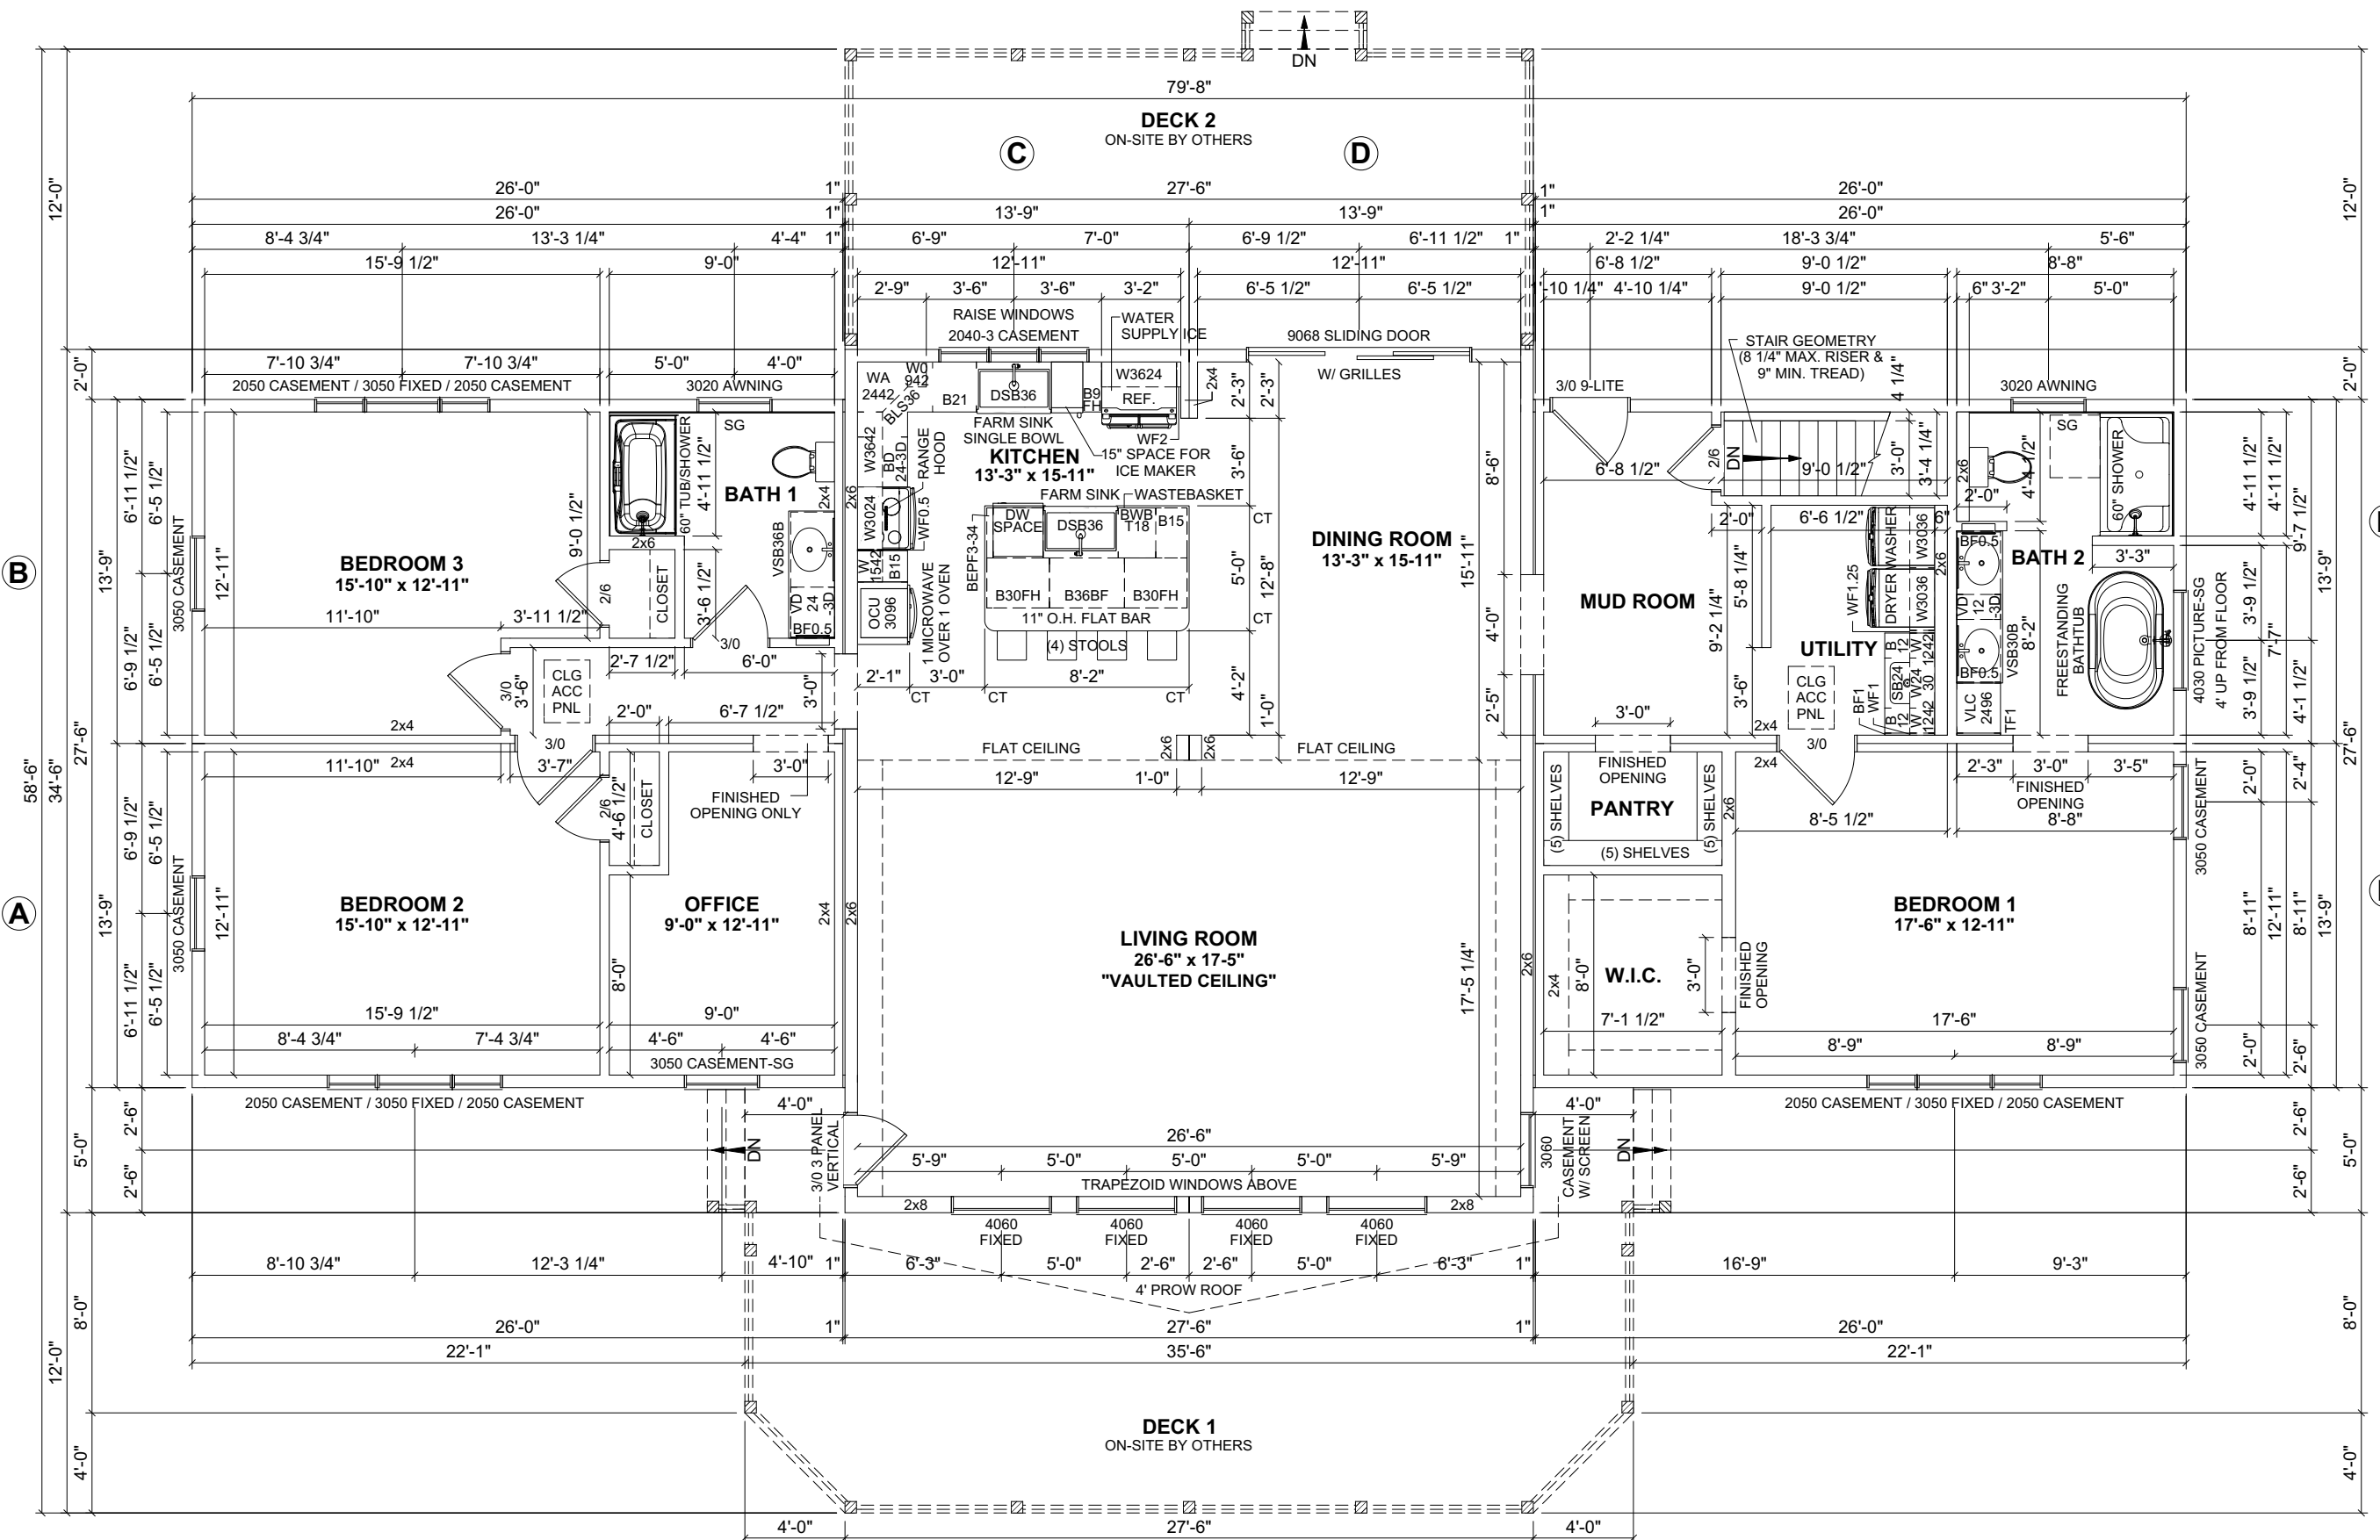

- NOTES:**
1. 2x6 EXTERIOR WALLS EXCEPT AS NOTED.
  2. 2x4 INTERIOR WALLS EXCEPT AS NOTED.
  3. 8'-8" CEILING HEIGHT.
  4. 7/12 NON-STORAGE ROOF EXCEPT AS NOTED.

- NOTE:**
- 1: ALL WINDOWS TO BE MARVIN SIGNATURE COLLECTION MODERN - ALUMINUM INTERIOR, FIBERGLASS EXTERIOR. COLOR = EBONY, NARROW FRAME, SQUARE SURFACE DUAL PANE, MATTE BLACK MODERN HARDWARE
  - 2: PICTURE, TRAP AND TRIANGLE WINDOWS ARE FIXED.
  - 3: INCLUDE MARVIN BRIGHT VIEW SCREENS.
  - 4: THE MARVIN ULTIMATE SLIDING DOORS WOOD INTERIOR ALUMINUM EXTERIOR, SLIDING SCREEN DOOR, SAME AS THE BLACK HARDWARE.

**FLOOR AREA: 2,383 SQ.FT.**  
**DECK 1: 450 SQ.FT.**  
**DECK 2: 330 SQ.FT.**  
**TOTAL AREA: 780 SQ.FT.**

REVISION:	DATE:	BY:	REVISION:	DATE:	BY:
0	05/09/2023	SC	6	11/14/2023	SC
1	07/20/2023	SC	7	12/31/2023	SC
2	07/21/2023	SC	8	01/06/2024	SC
3	09/15/2023	SC	9	02/23/2024	SC
4	09/19/2023	SC	10	03/02/2024	SC
5	09/28/2023	SC	11	03/06/2024	SC

# FLOOR PLAN

CUSTOMER:

ADDRESS:

**impresa**  
MODULAR

1566 WINCHESTER AVE.  
 MARTINSBURG, WV 25405  
 FAX: 877-419-2505  
 WWW.IMPRESAMODULAR.COM

SCALE:

N.T.S.

SHEET:

3.0

**DISCLAIMER:** THESE DRAWINGS ARE ARTISTS RENDERINGS ONLY AND FINAL PROJECT MAY NOT BE IDENTICAL TO THAT SHOWN HERE. PROPRIETARY WORK PRODUCT AND PROPERTY OF EXPRESS HOMES, INC. DBA IMPRESA MODULAR AND DEVELOPED FOR THE EXCLUSIVE USE OF IMPRESA MODULAR. USE OF THESE DRAWINGS AND CONCEPTS CONTAINED THEREIN WITHOUT WRITTEN PERMISSION OF IMPRESA MODULAR IS PROHIBITED.